


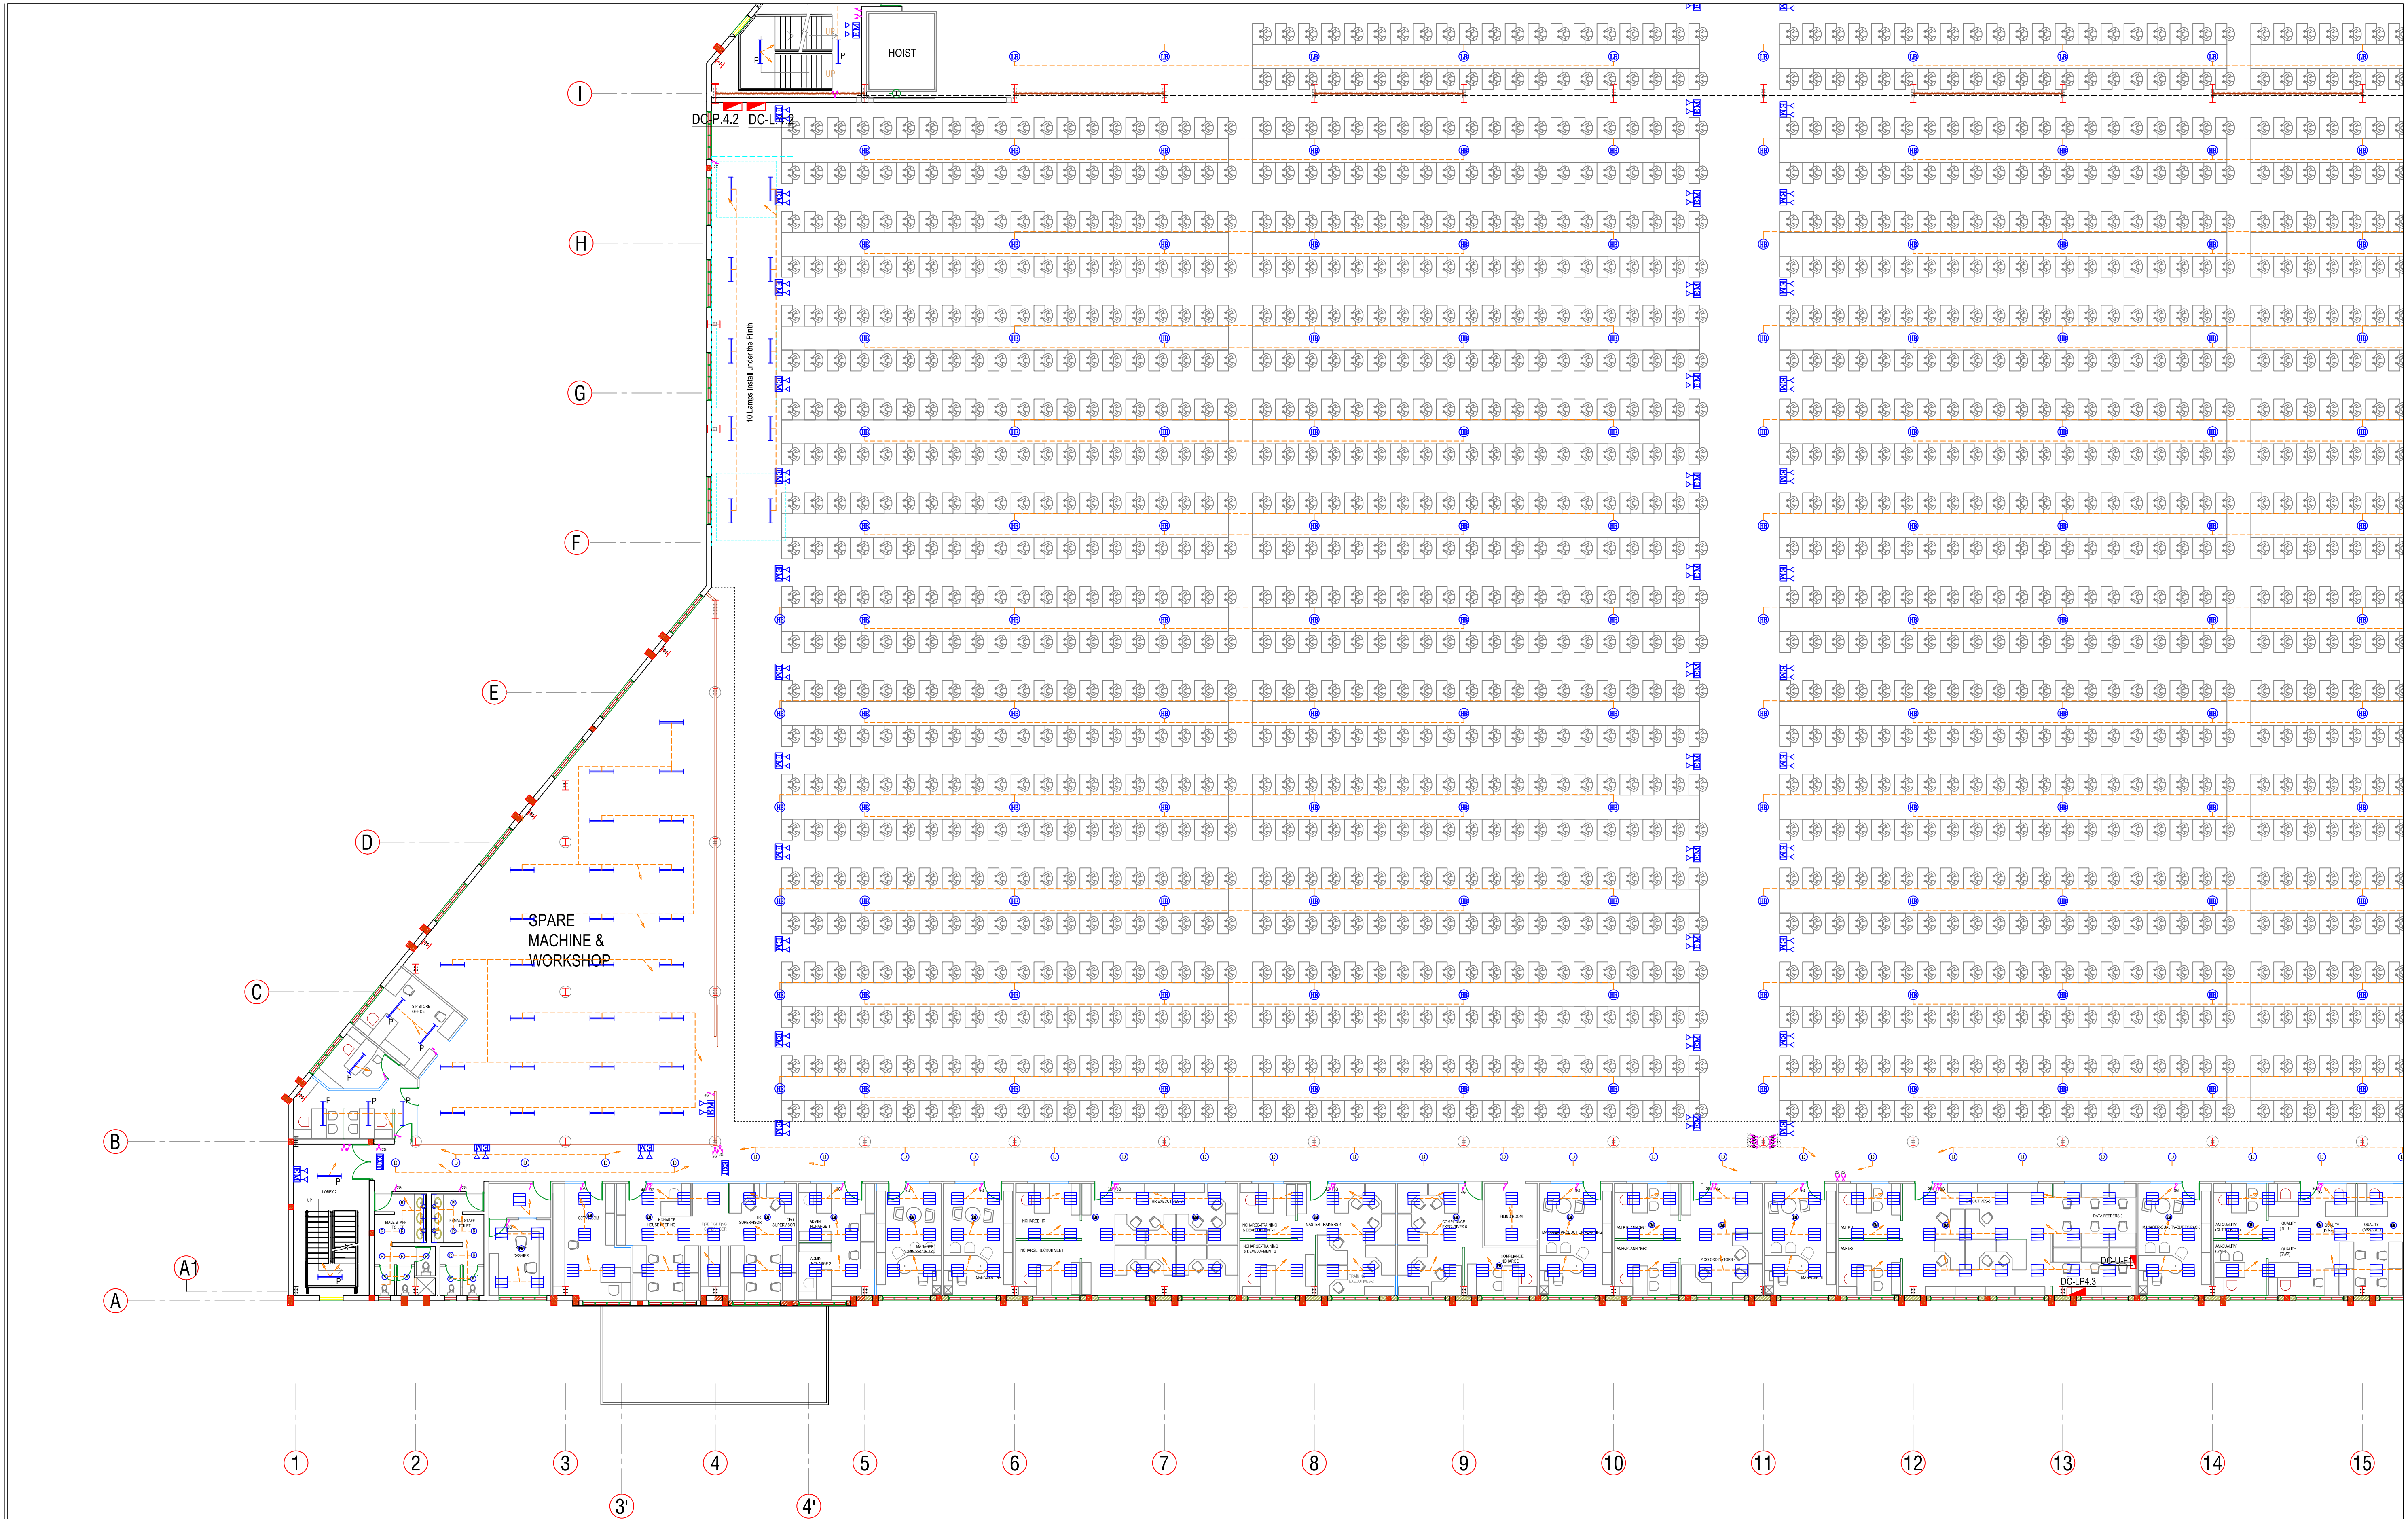

Project Title		Project Consultant				VERIFY ALL DIMENSIONS ON SITE BEFORE COMMENCING WORK. COPYING OR THE REPRODUCTION OF THIS DRAWING IS STRICTLY PROHIBITED WITHOUT THE CONSENT OF NJ CONSULTANTS	
PROPOSED FACTORY FOR SOORTY TEXTILES (BD) LTD. PLOT NO 220-227, COMILLA EXPORT PROCESSING ZONE COMILLA - 3500, BANGLADESH		 NJ CONSULTANTS 35A, 1/3, SUNETHRADEVI ROAD, KOHUWALA SRI LANKA TEL : 94-11-2614069, 94-11-4002365 FAX : 94-11-4002365 E-MAIL : noel@njc.com				Drawing Title	
						ELECTRICAL INSTALLATION FIRST FLOOR - GRID 1 - 15 & A - I LIGHTING LAYOUT	
						Drawing Status	
						TENDER	
				Rev.		Description	
						Date	
						Made By	
						Drawn	
						CADTEAM	
						Date	
						OCT 2013	
						Checked	
						NJ	
						Scale	
						1 : 150 © A1	
						Approved	
						Job No.	
						File Path	
						Dwg No.	
						Revision	
						E-F-L-101	
						R0	