


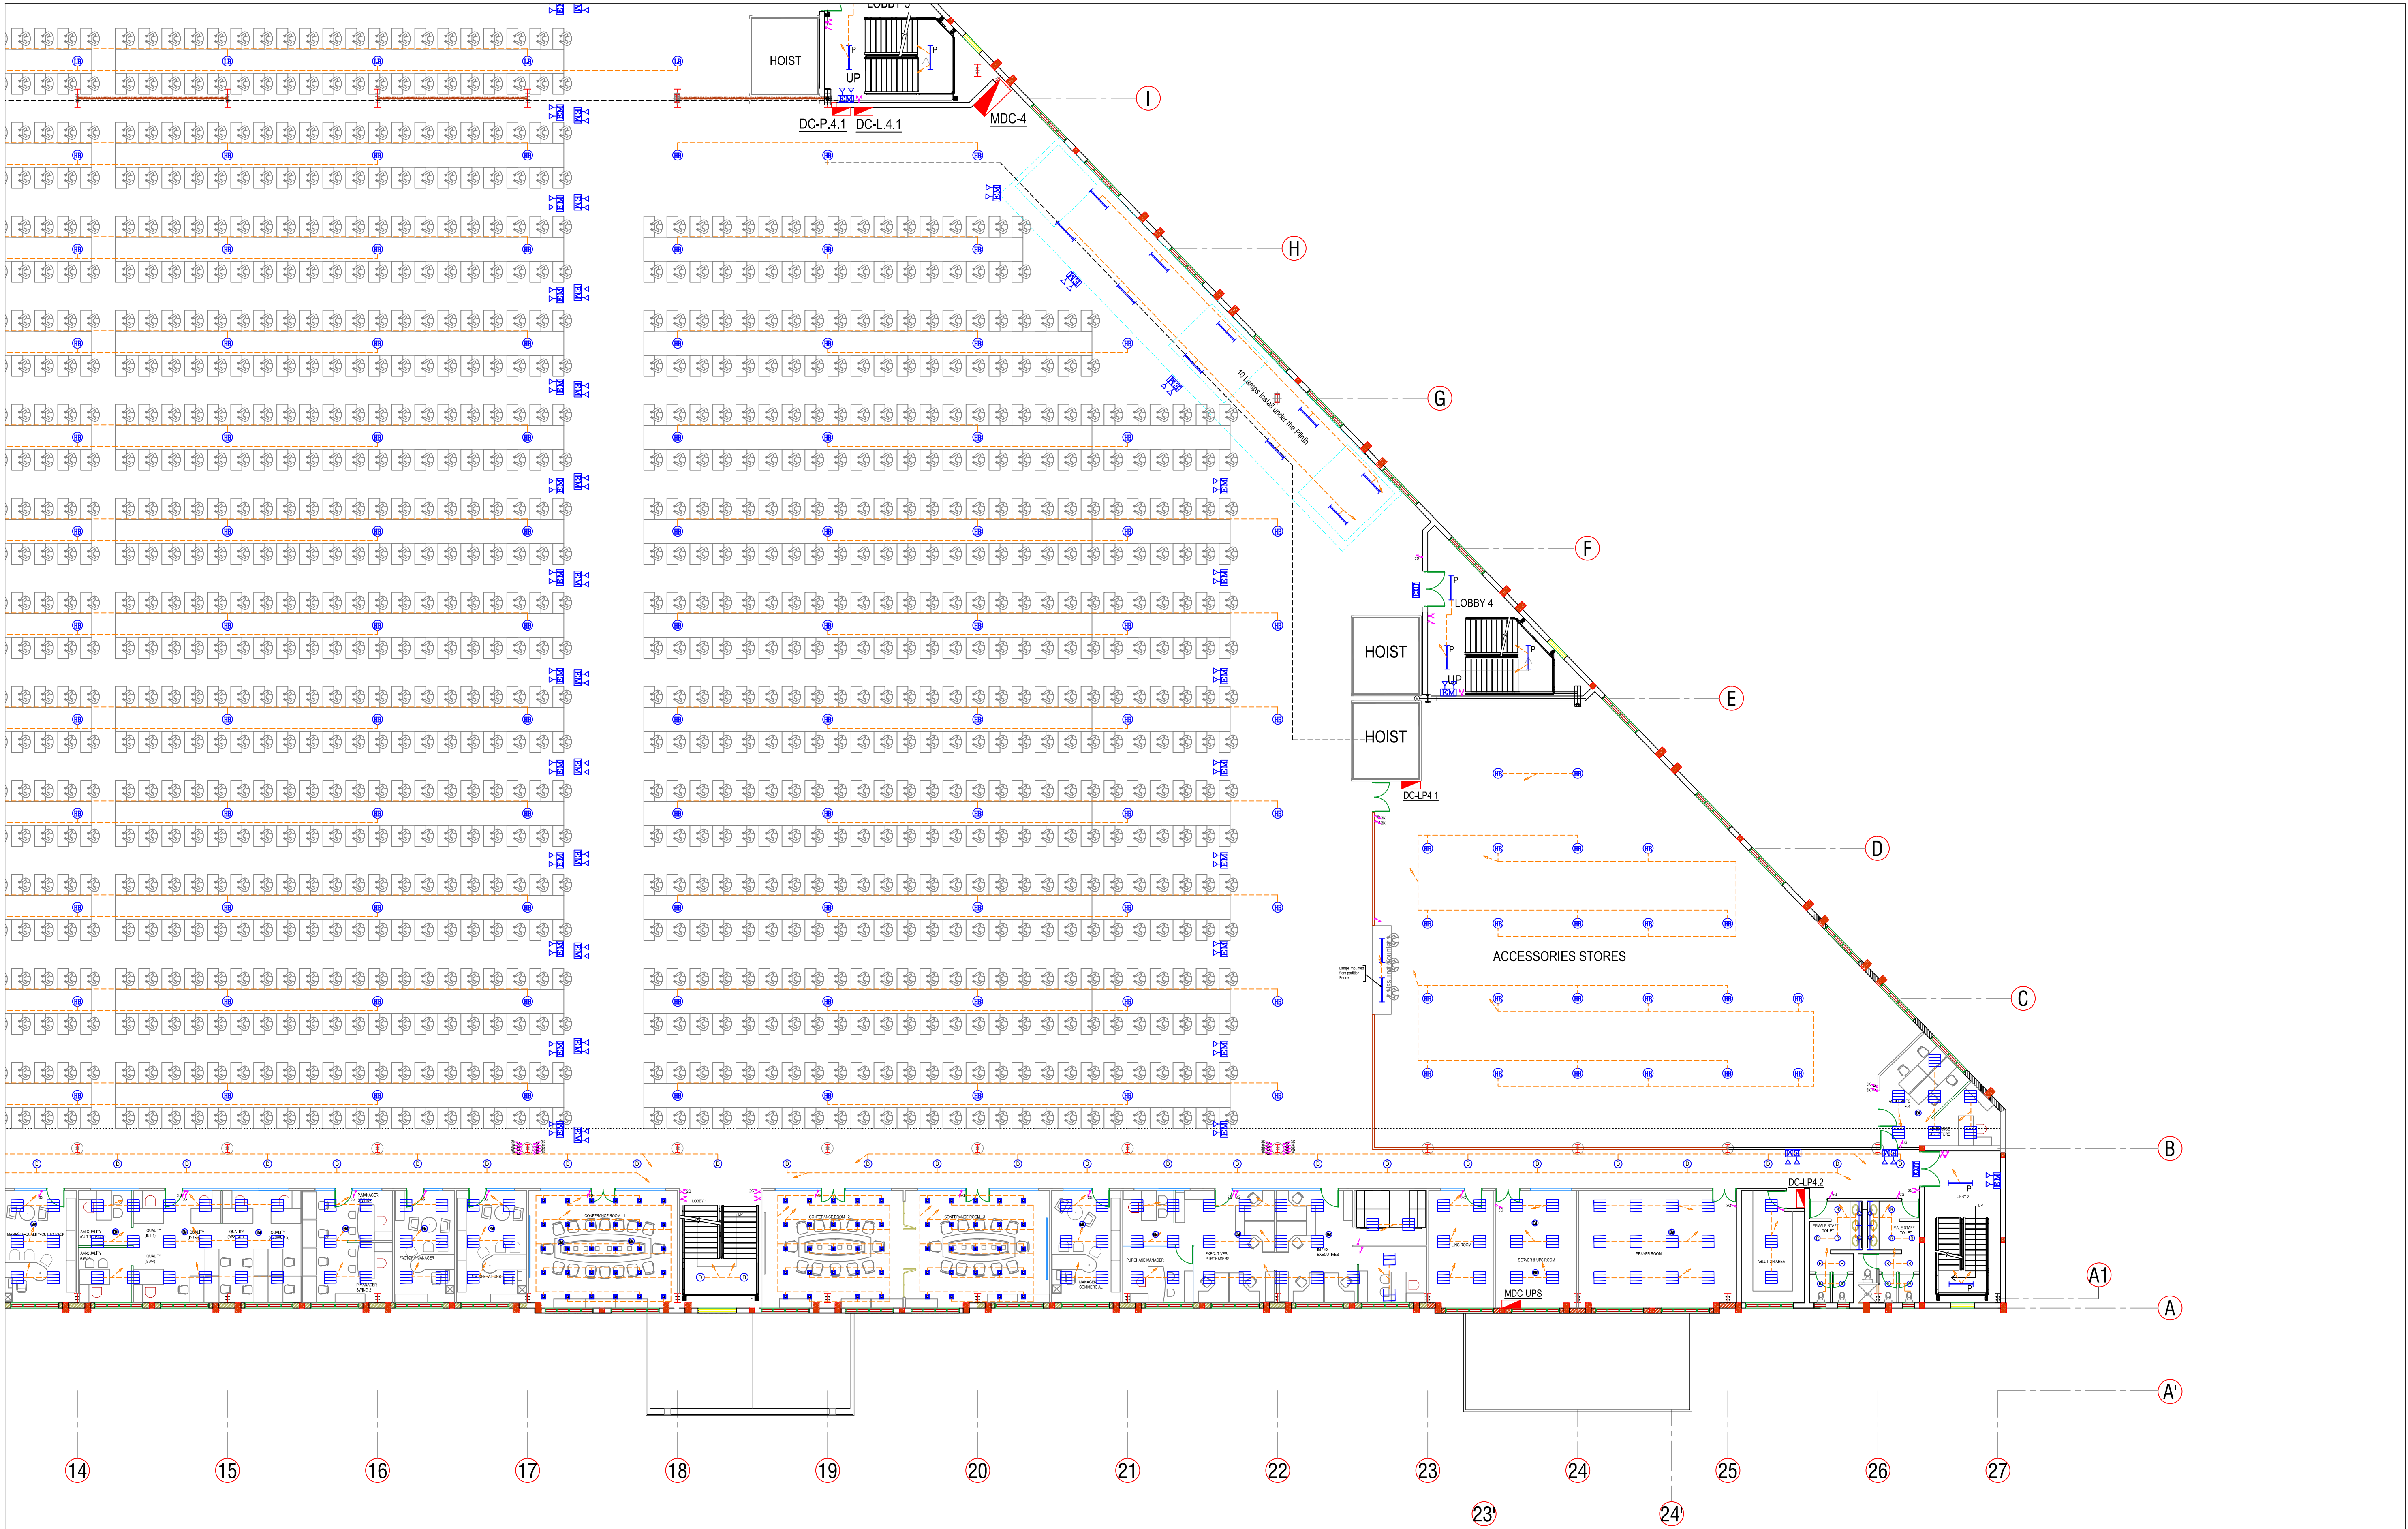

Project Title		Project Consultant								VERIFY ALL DIMENSIONS ON SITE BEFORE COMMENCING WORK COPYING OR THE REPRODUCTION OF THIS DRAWING IS STRICTLY PROHIBITED WITHOUT THE CONSENT OF NJ CONSULTANTS						
PROPOSED FACTORY FOR SOORTY TEXTILES (BD) LTD. PLOT NO 220-227, COMILLA EXPORT PROCESSING ZONE COMILLA - 3500, BANGLADESH		 NJ CONSULTANTS 35A, 1/3, SUNIETHRADEVI ROAD, KOHUWALA SRI LANKA TEL : 94-11-2814069, 94-11-4002365 FAX : 94-11-4002365 E-MAIL : noel@njc.lk								Drawing Title		Drawn	CADTEAM	Date	OCT 2013	
										ELECTRICAL INSTALLATION FIRST FLOOR - GRID 15 - 27 & A - I LIGHTING LAYOUT		Checked		NJ	Scale	1 : 150 @ A1
												Approved		Job No.		
												File Path				
														Rev.		Description