


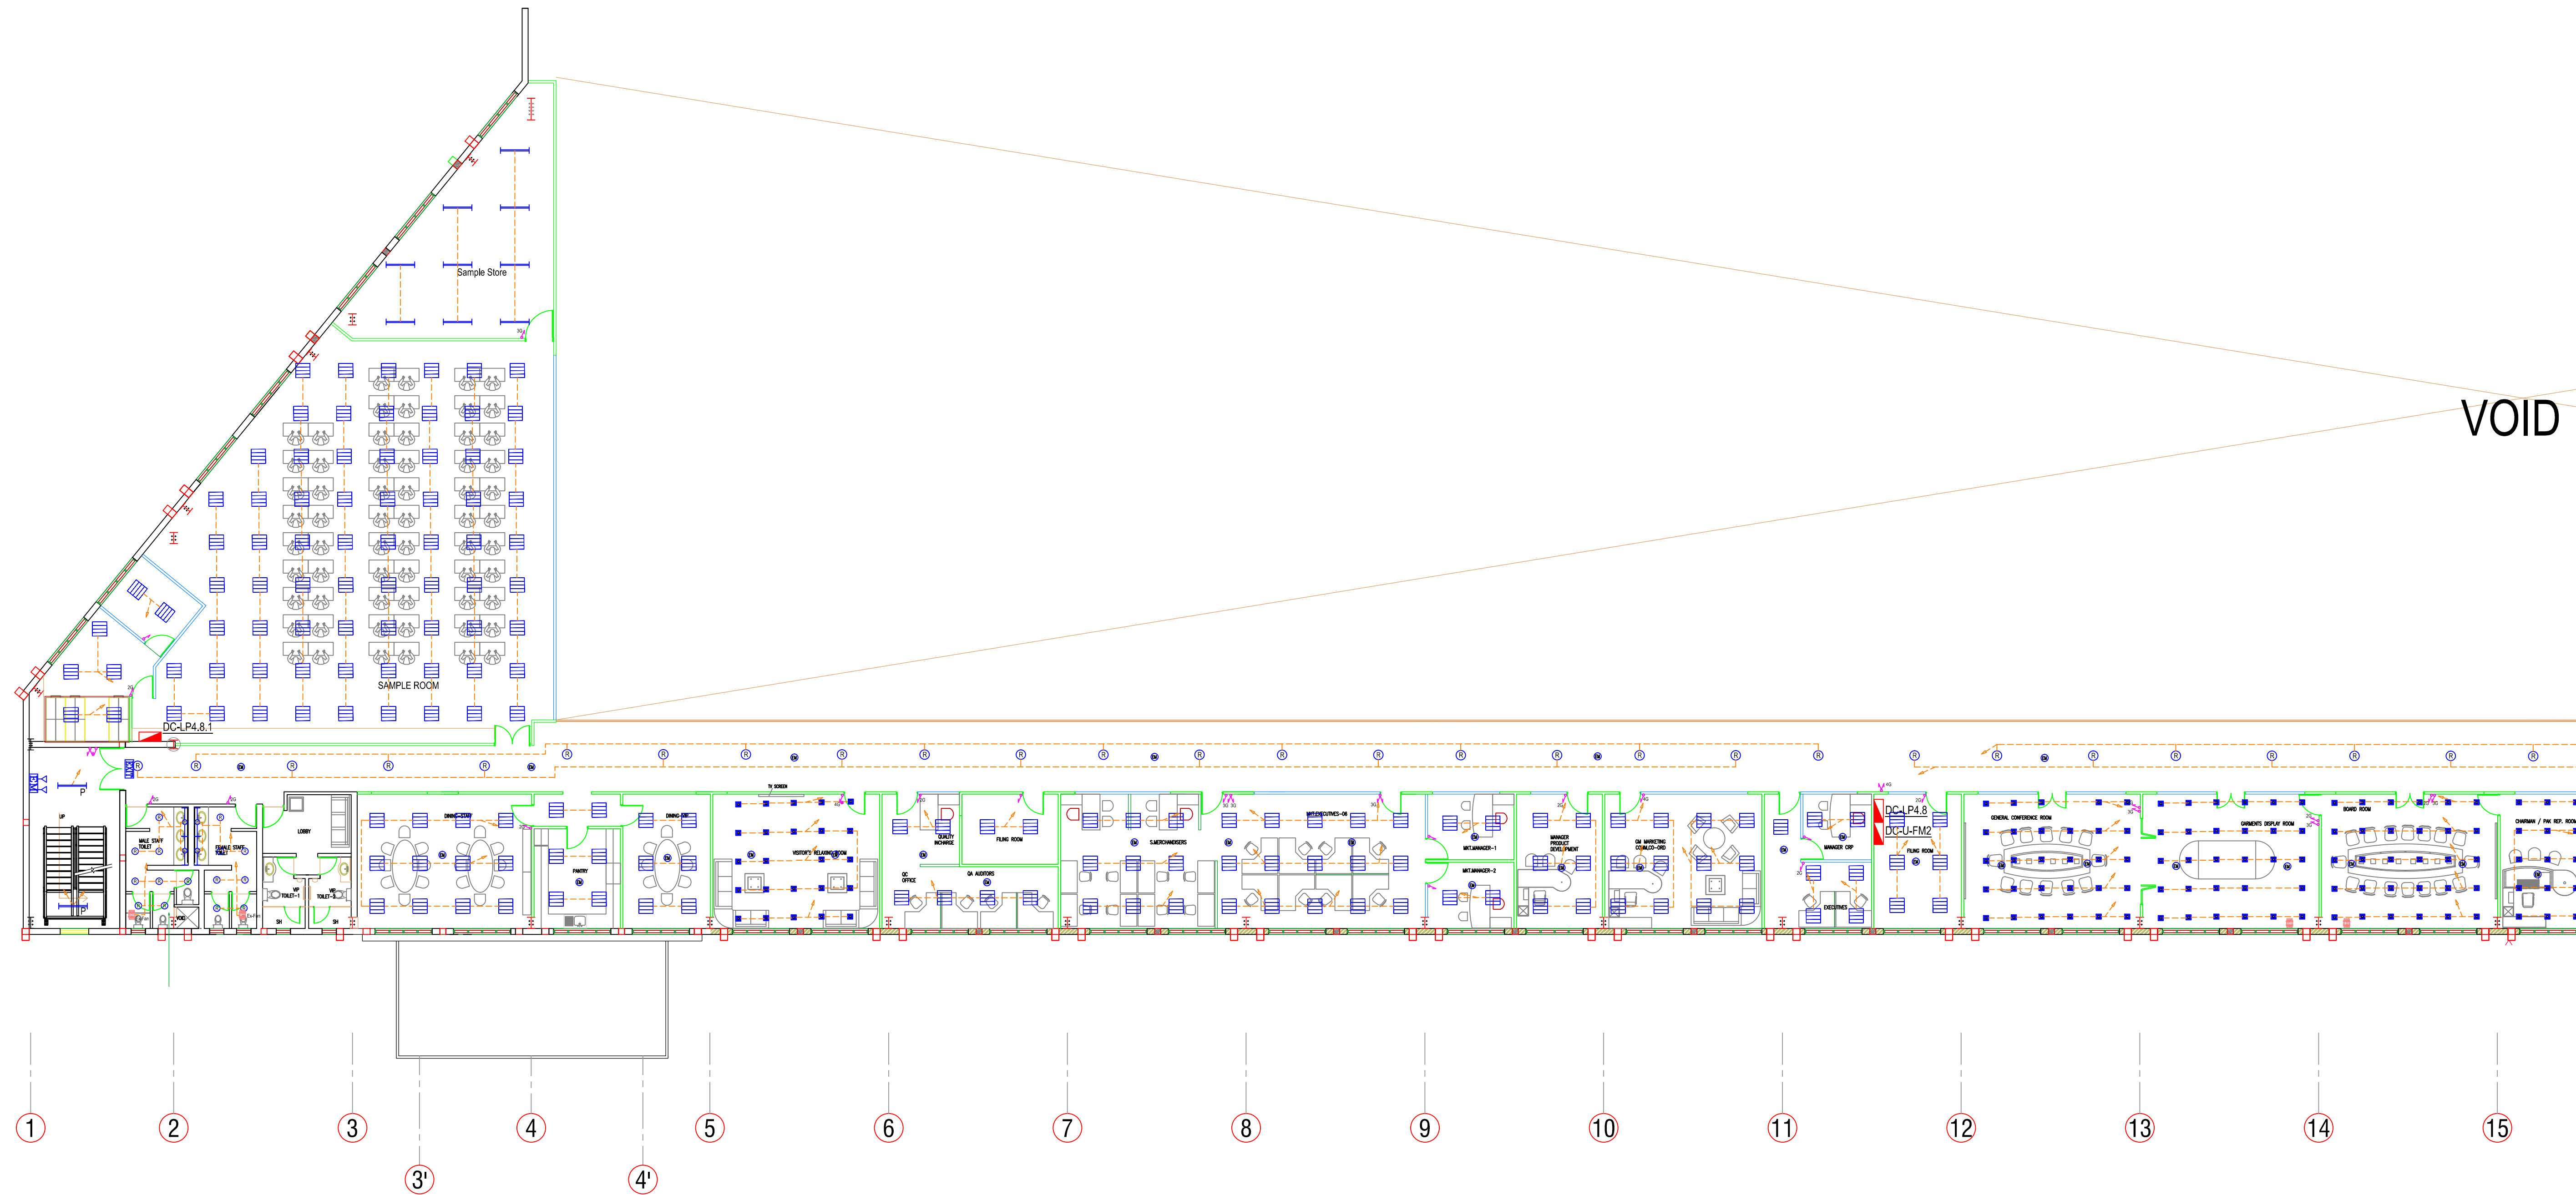

MEZZANINE FLOOR PLAN

Project Title		Project Consultant						VERIFY ALL DIMENSIONS ON SITE BEFORE COMMENCING WORK COPYING OR THE REPRODUCTION OF THIS DRAWING IS STRICTLY PROHIBITED WITHOUT THE CONSENT OF NJ CONSULTANTS	
PROPOSED FACTORY FOR SOORTY TEXTILES (BD) LTD. PLOT NO 220-227, COMILLA EXPORT PROCESSING ZONE COMILLA - 3500, BANGLADESH		n CONSULTANTS NJ CONSULTANTS 35A, 1/3, SUNETHRADEVI ROAD, KOHUWALA SRI LANKA TEL : 94-11-2814069, 94-11-4002365 FAX : 94-11-4002365 E-MAIL : noel@njc.com						Drawing Title	Drawn CADTEAM Date OCT 2013
								ELECTRICAL INSTALLATION MEZZANINE FLOOR IN FIRST LEVEL LIGHTING LAYOUT (GRID 1 to 15)	Checked NJ Scale 1 : 150 @ A1
									Approved Job No.
									File Path
				Rev.	Description	Date	Made By	Drawing Status	Dwg No. Revision
								TENDER	E-FM-L-101 R0