


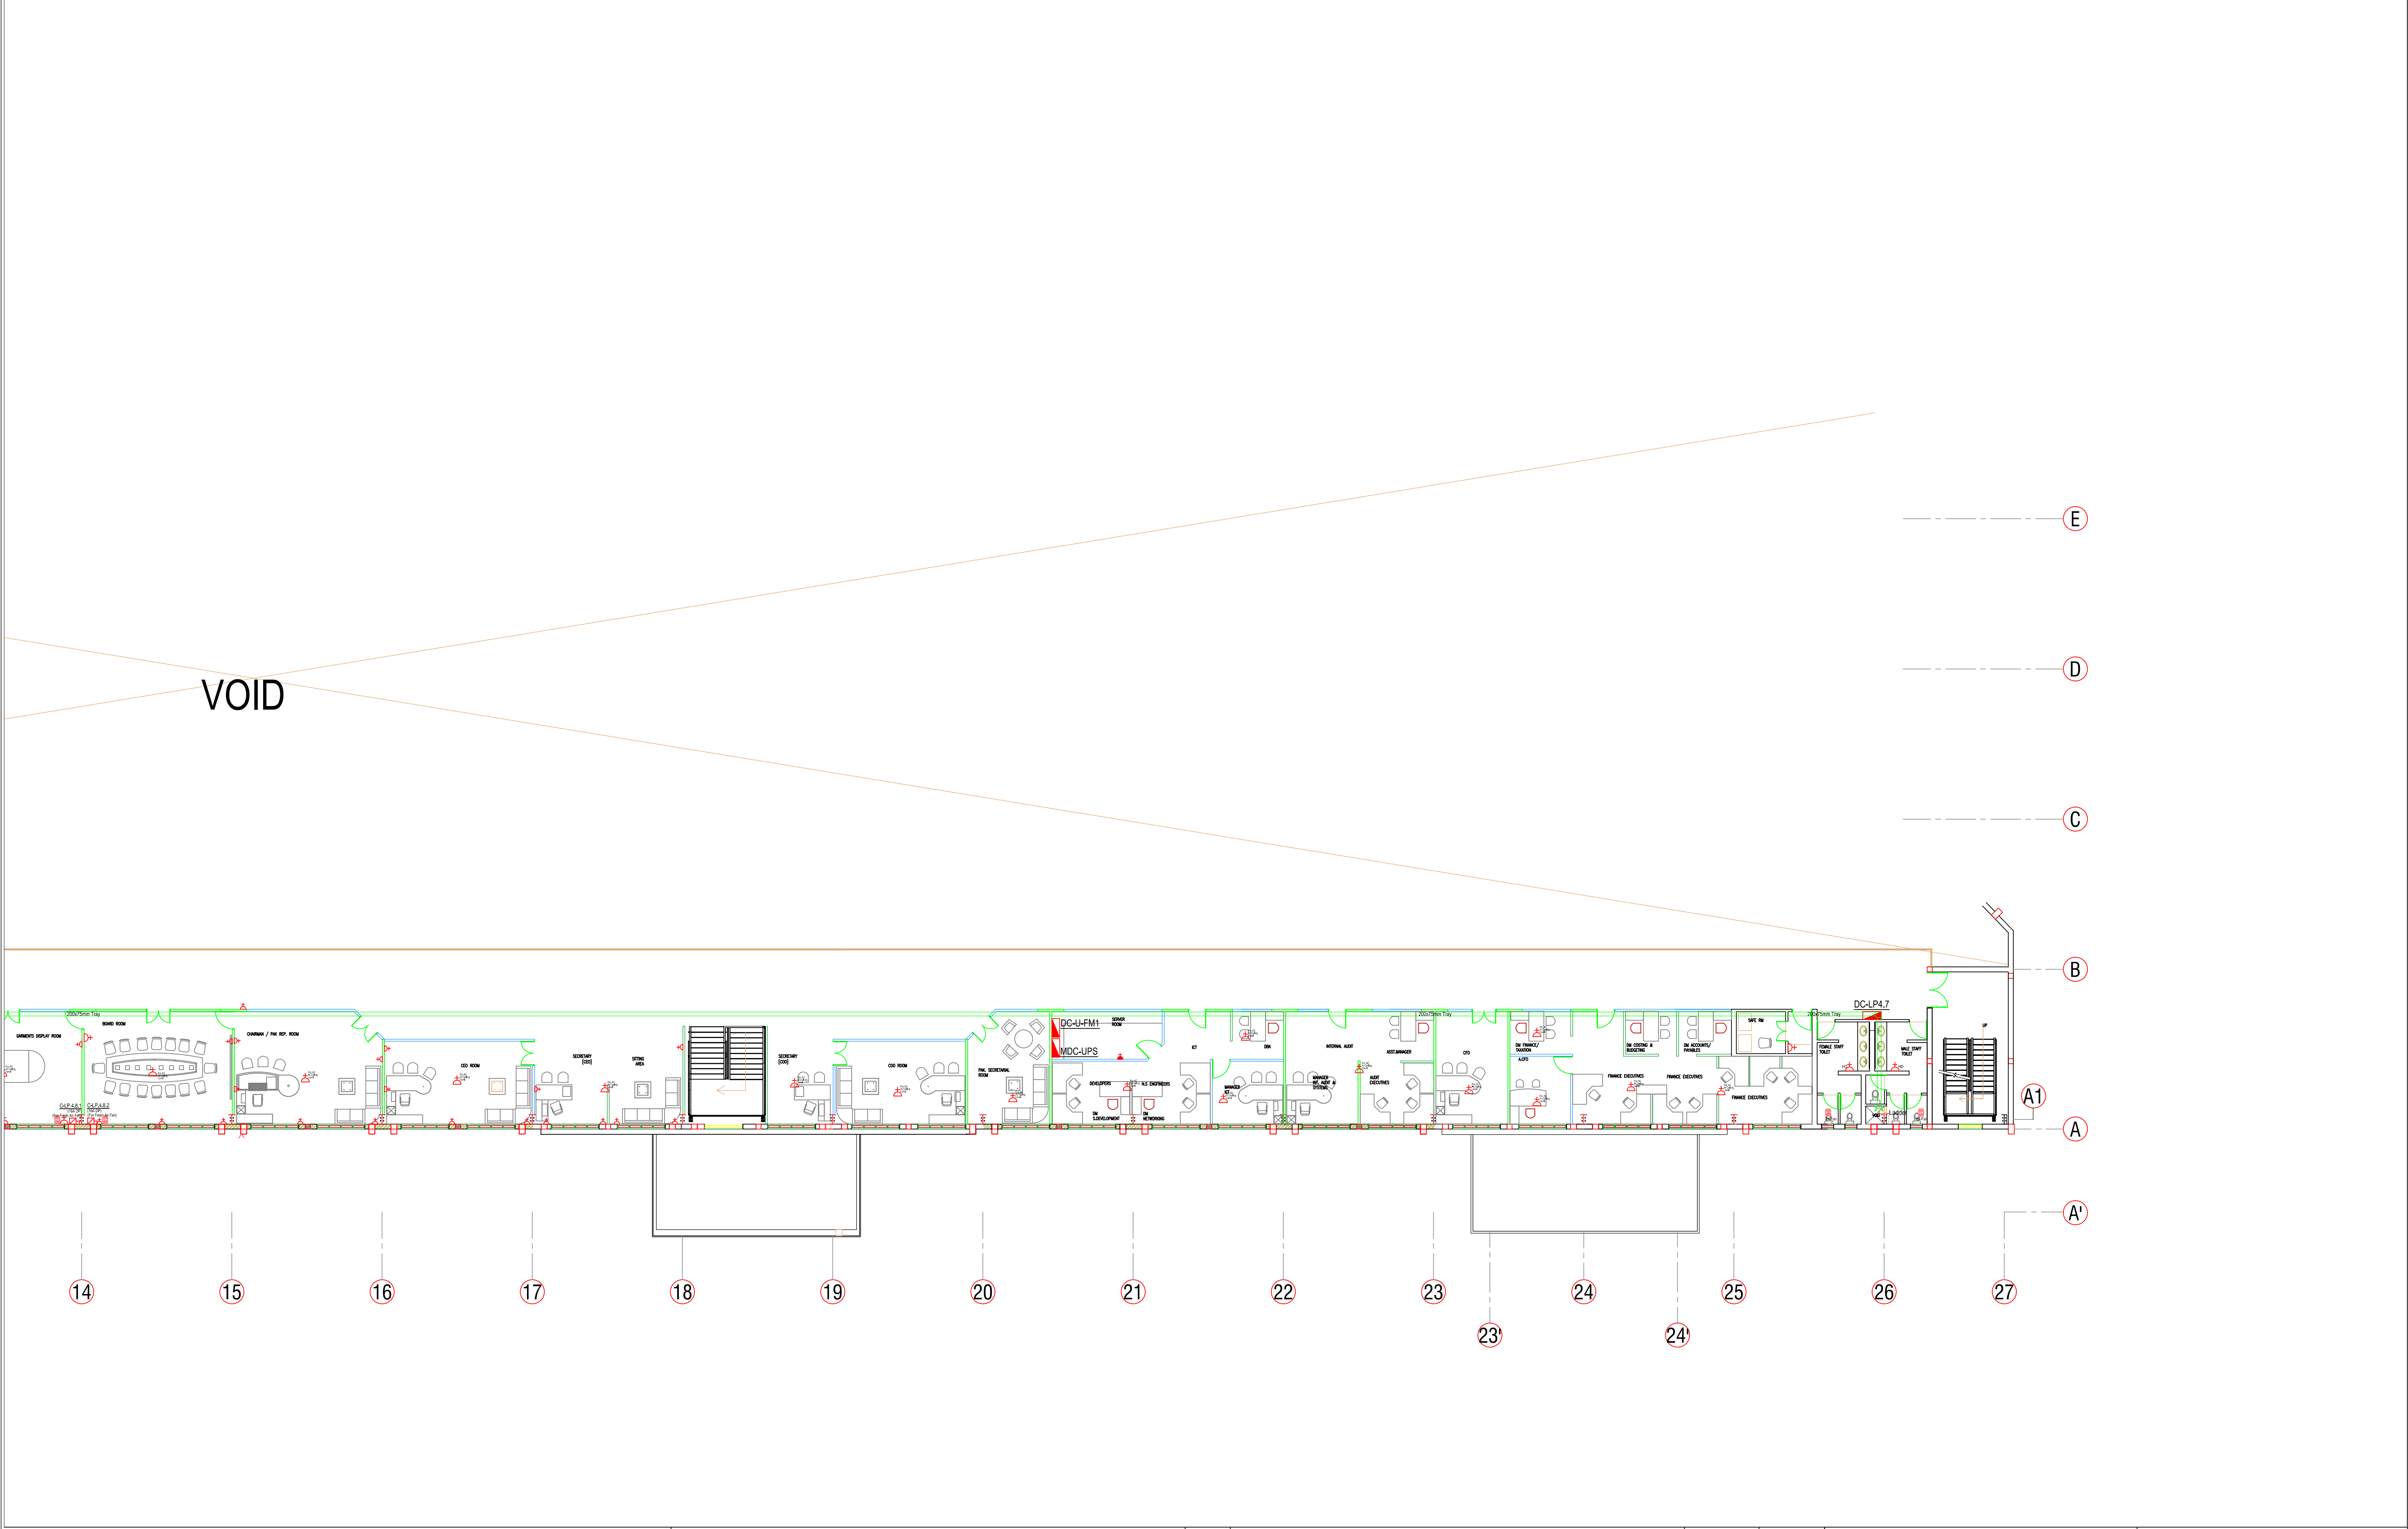

Project Title		Project Consultant						VERIFY ALL DIMENSIONS ON SITE BEFORE COMMENCING WORK. COPYING OR THE REPRODUCTION OF THIS DRAWING IS STRICTLY PROHIBITED WITHOUT THE CONSENT OF NJ CONSULTANTS	
PROPOSED FACTORY FOR SOORTY TEXTILES (BD) LTD. PLOT NO 220-227, COMILLA EXPORT PROCESSING ZONE COMILLA - 3500, BANGLADESH		n CONSULTANTS NJ CONSULTANTS 35A, 1/3, SUNETHRADEVI ROAD, KOHUWALA SRI LANKA TEL : 94-11-2814069, 94-11-4002365 FAX : 94-11-4002365 E-MAIL : noel@njc.lk						Drawing Title	Drawn CADTEAM Date OCT 2013
								ELECTRICAL INSTALLATION MEZZANINE FLOOR IN FIRST LEVEL POWER LAYOUT (GRID 15 TO 27)	Checked NJ Scale 1 : 150 @ A1
									Approved Job No.
									File Path
								Dwg No.	Revision
								E-FM-P-102	R0
Rev.		Description					Date	Made By	Drawing Status
									TENDER