


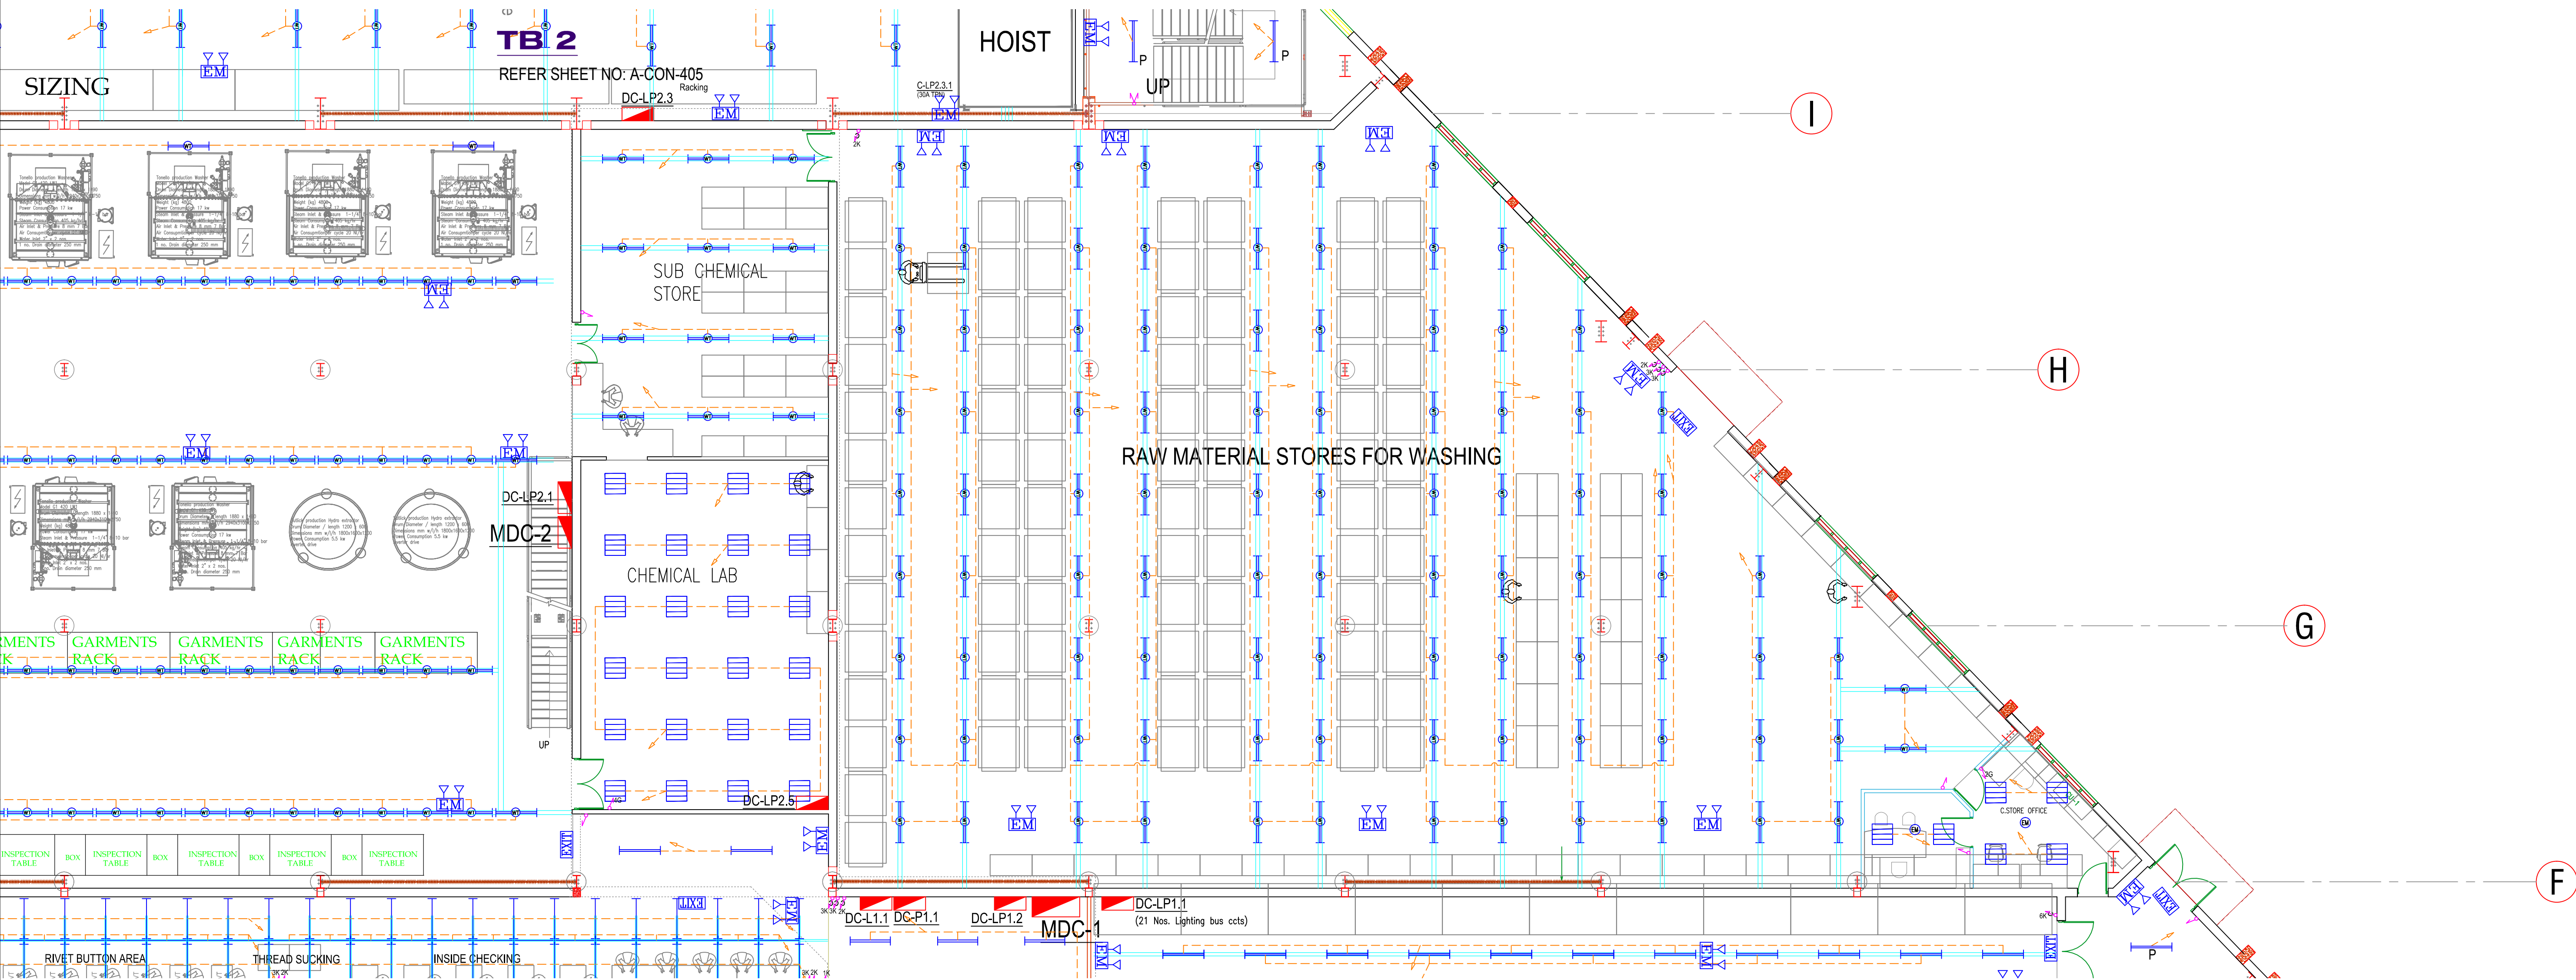

|                                                                                                                                       |  |                                                                                                                                                                                                                                                                          |  |      |  |             |  |                                                                                                                                                                     |  |                               |  |
|---------------------------------------------------------------------------------------------------------------------------------------|--|--------------------------------------------------------------------------------------------------------------------------------------------------------------------------------------------------------------------------------------------------------------------------|--|------|--|-------------|--|---------------------------------------------------------------------------------------------------------------------------------------------------------------------|--|-------------------------------|--|
| Project Title                                                                                                                         |  | Project Consultant                                                                                                                                                                                                                                                       |  |      |  |             |  | VERIFY ALL DIMENSIONS ON SITE BEFORE COMMENCING WORK<br>COPYING OR THE REPRODUCTION OF THIS DRAWING IS STRICTLY<br>PROHIBITED WITHOUT THE CONSENT OF NJ CONSULTANTS |  |                               |  |
| PROPOSED FACTORY FOR<br>SOORTY TEXTILES (BD) LTD.<br>PLOT NO 220-227,<br>COMILLA EXPORT PROCESSING ZONE<br>COMILLA - 3500, BANGLADESH |  |  <div>NJ CONSULTANTS<br/>35A, 1/3, SUNETHRADEVI ROAD,<br/>KOHUWALA<br/>SRI LANKA<br/><br/>TEL : 94-11-2814069, 94-11-4002365<br/>FAX : 94-11-4002365<br/>E-MAIL : noel@njcl.com</div> |  |      |  |             |  | Drawing Title<br>ELECTRICAL INSTALLATION<br>GROUND FLOOR PLAN<br>LAB & CHEMICAL STORES<br>LIGHTING LAYOUT                                                           |  | Drawn CADTEAM Date AUG 2013   |  |
|                                                                                                                                       |  |                                                                                                                                                                                                                                                                          |  |      |  |             |  |                                                                                                                                                                     |  | Checked NJ Scale 1 : 100 @ A1 |  |
|                                                                                                                                       |  |                                                                                                                                                                                                                                                                          |  |      |  |             |  |                                                                                                                                                                     |  | Approved Job No.              |  |
|                                                                                                                                       |  |                                                                                                                                                                                                                                                                          |  |      |  |             |  |                                                                                                                                                                     |  | File Path                     |  |
|                                                                                                                                       |  |                                                                                                                                                                                                                                                                          |  |      |  |             |  |                                                                                                                                                                     |  | Dwg No. Revision              |  |
|                                                                                                                                       |  |                                                                                                                                                                                                                                                                          |  | Rev. |  | Description |  | Date                                                                                                                                                                |  | Made By                       |  |
|                                                                                                                                       |  |                                                                                                                                                                                                                                                                          |  |      |  |             |  | Drawing Status                                                                                                                                                      |  | TENDER                        |  |
|                                                                                                                                       |  |                                                                                                                                                                                                                                                                          |  |      |  |             |  |                                                                                                                                                                     |  | E-G-CS-L-100 R0               |  |