


TB 2
REFER SHEET NO: A-CON-405

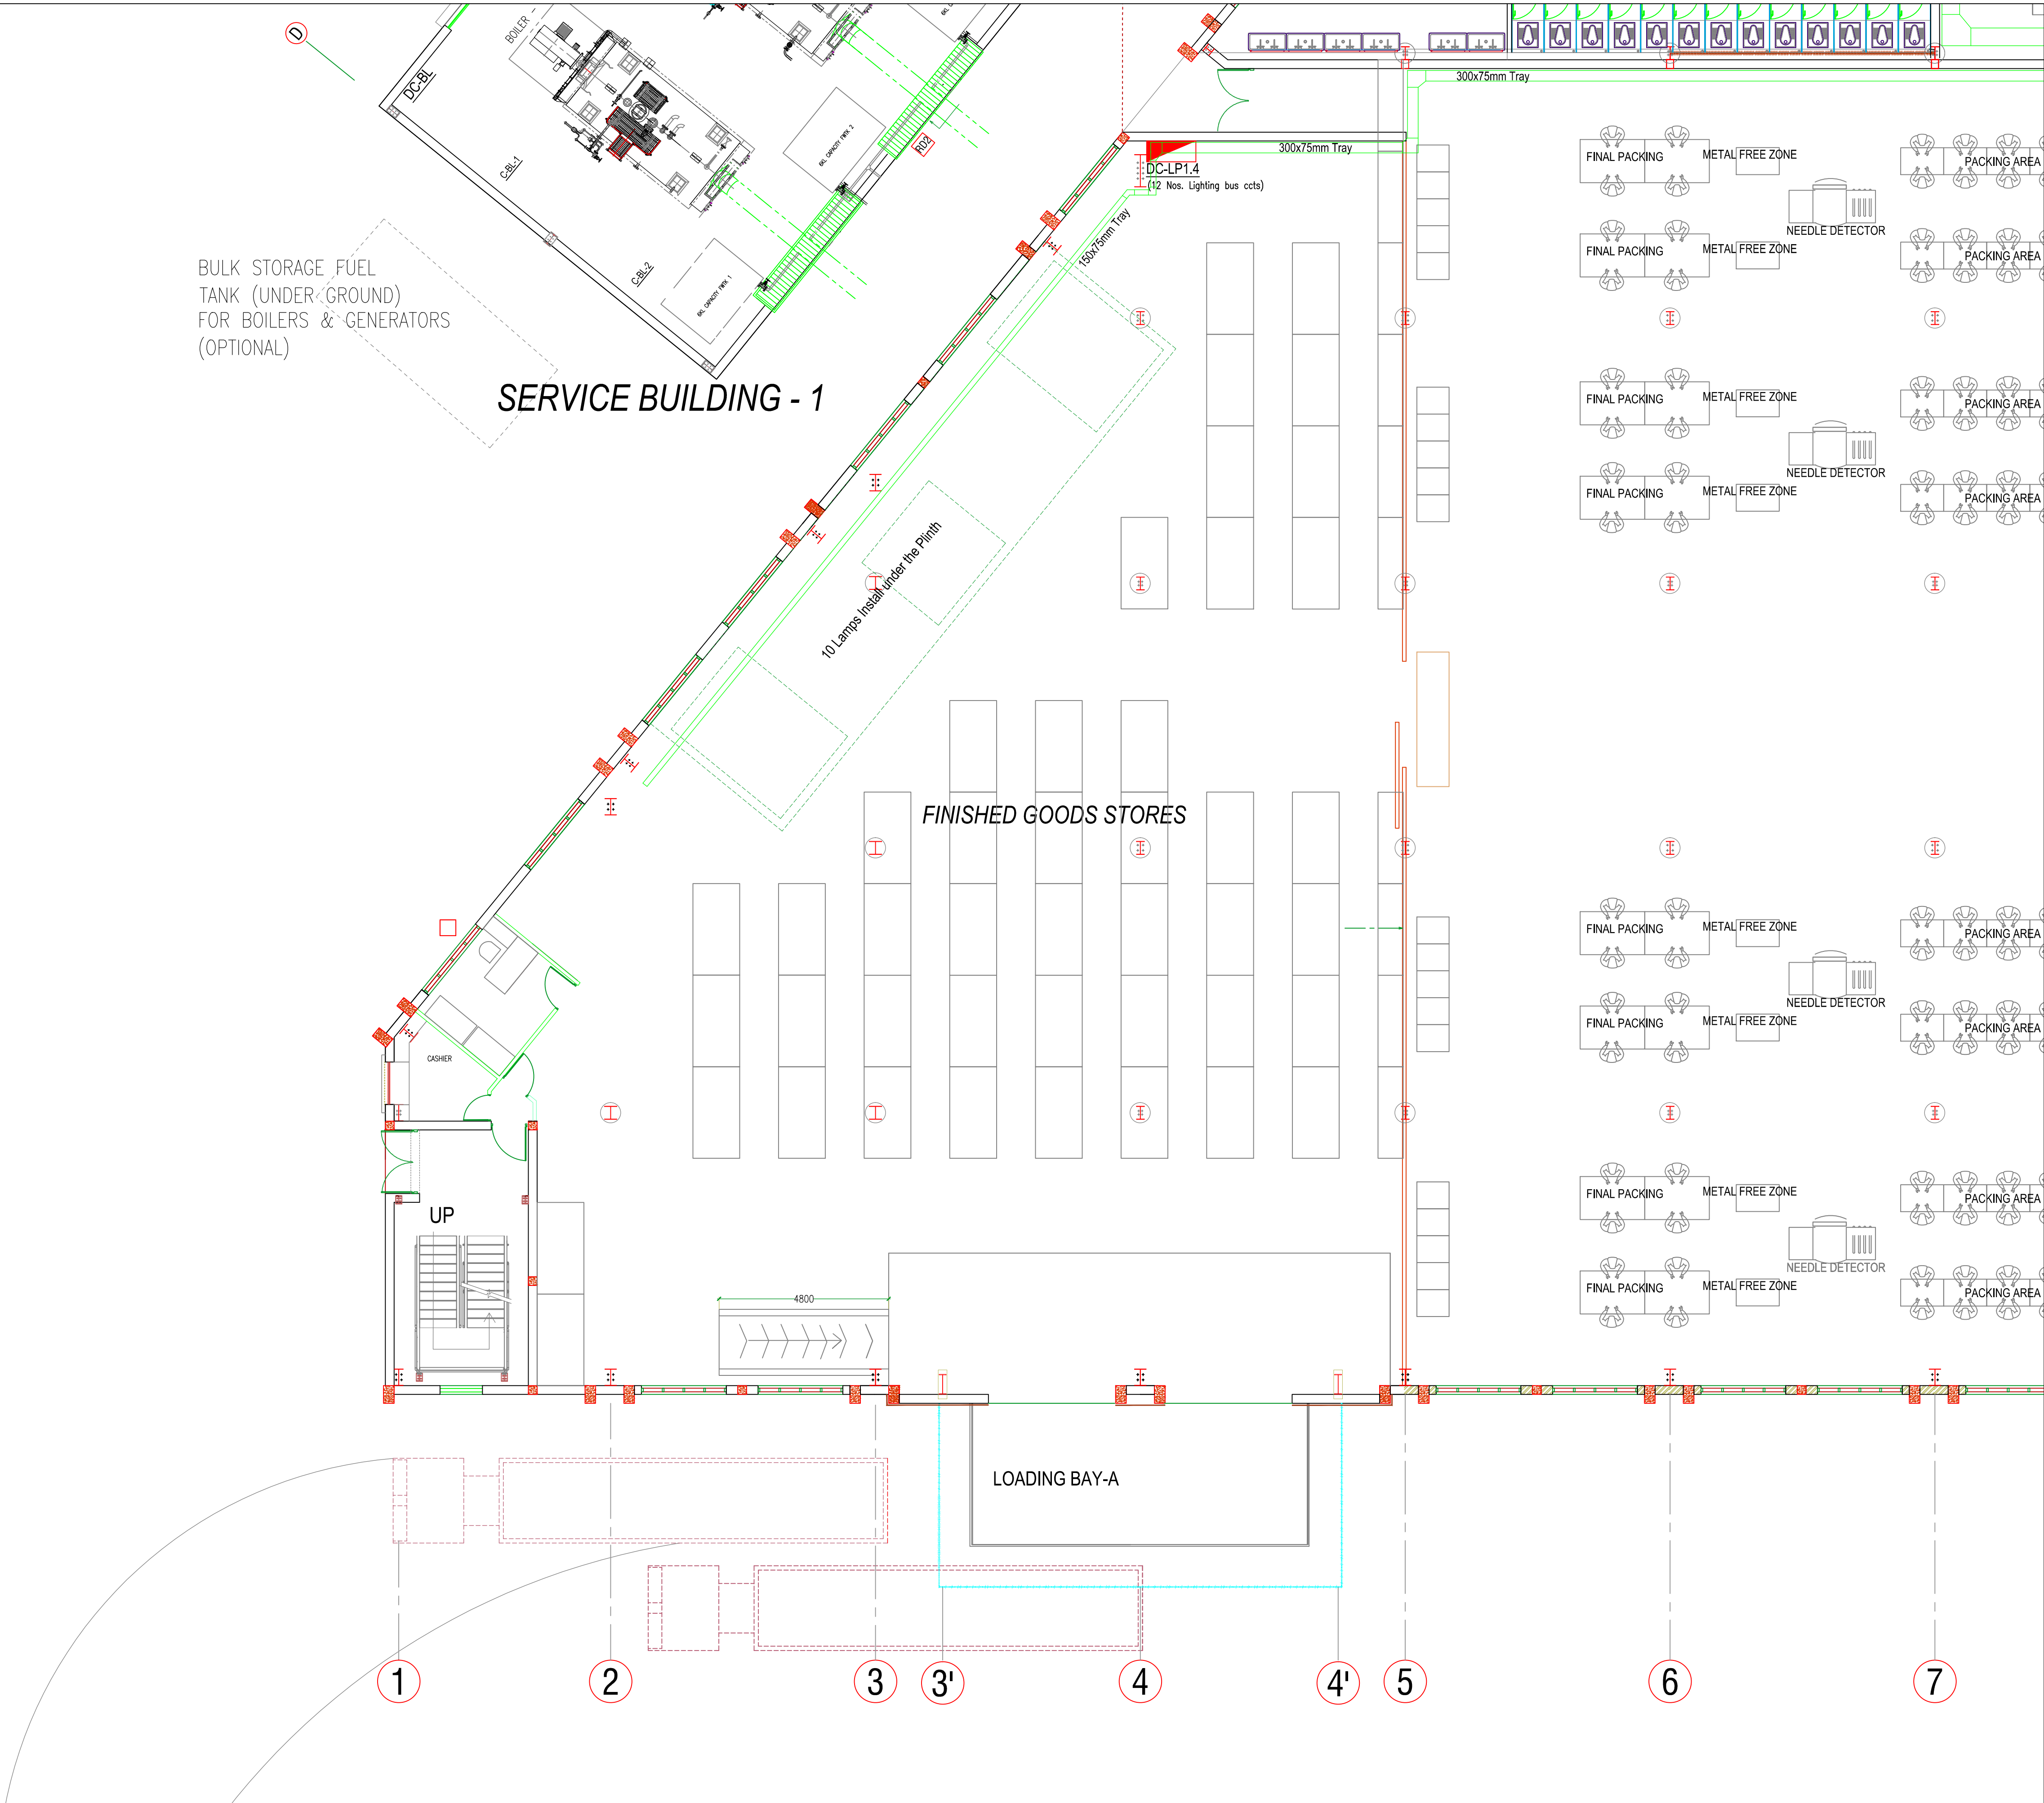

Project Title		Project Consultant						VERIFY ALL DIMENSIONS ON SITE BEFORE COMMENCING WORK COPYING OR THE REPRODUCTION OF THIS DRAWING IS STRICTLY PROHIBITED WITHOUT THE CONSENT OF NJ CONSULTANTS	
PROPOSED FACTORY FOR SOORTY TEXTILES (BD) LTD. PLOT NO 220-227, COMILLA EXPORT PROCESSING ZONE COMILLA - 3500, BANGLADESH		 NJ CONSULTANTS 35A, 1/3, SUNETHRADEVI ROAD, KOHUWALA SRI LANKA TEL : 94-11-2814069, 94-11-4002365 FAX : 94-11-4002365 E-MAIL : noel@njcslk.com						Drawing Title ELECTRICAL INSTALLATION GROUND FLOOR PLAN FINISH GOODS STORES POWER LAYOUT	
								Drawn CADTEAM Date AUG 2013	
								Checked NJ Scale 1 : 100 @ A1	
								Approved Job No.	
								File Path	
								Dwg No. Revision	
								E-G-FGS-P-100 R0	
				Rev.		Description		Date Made By	