


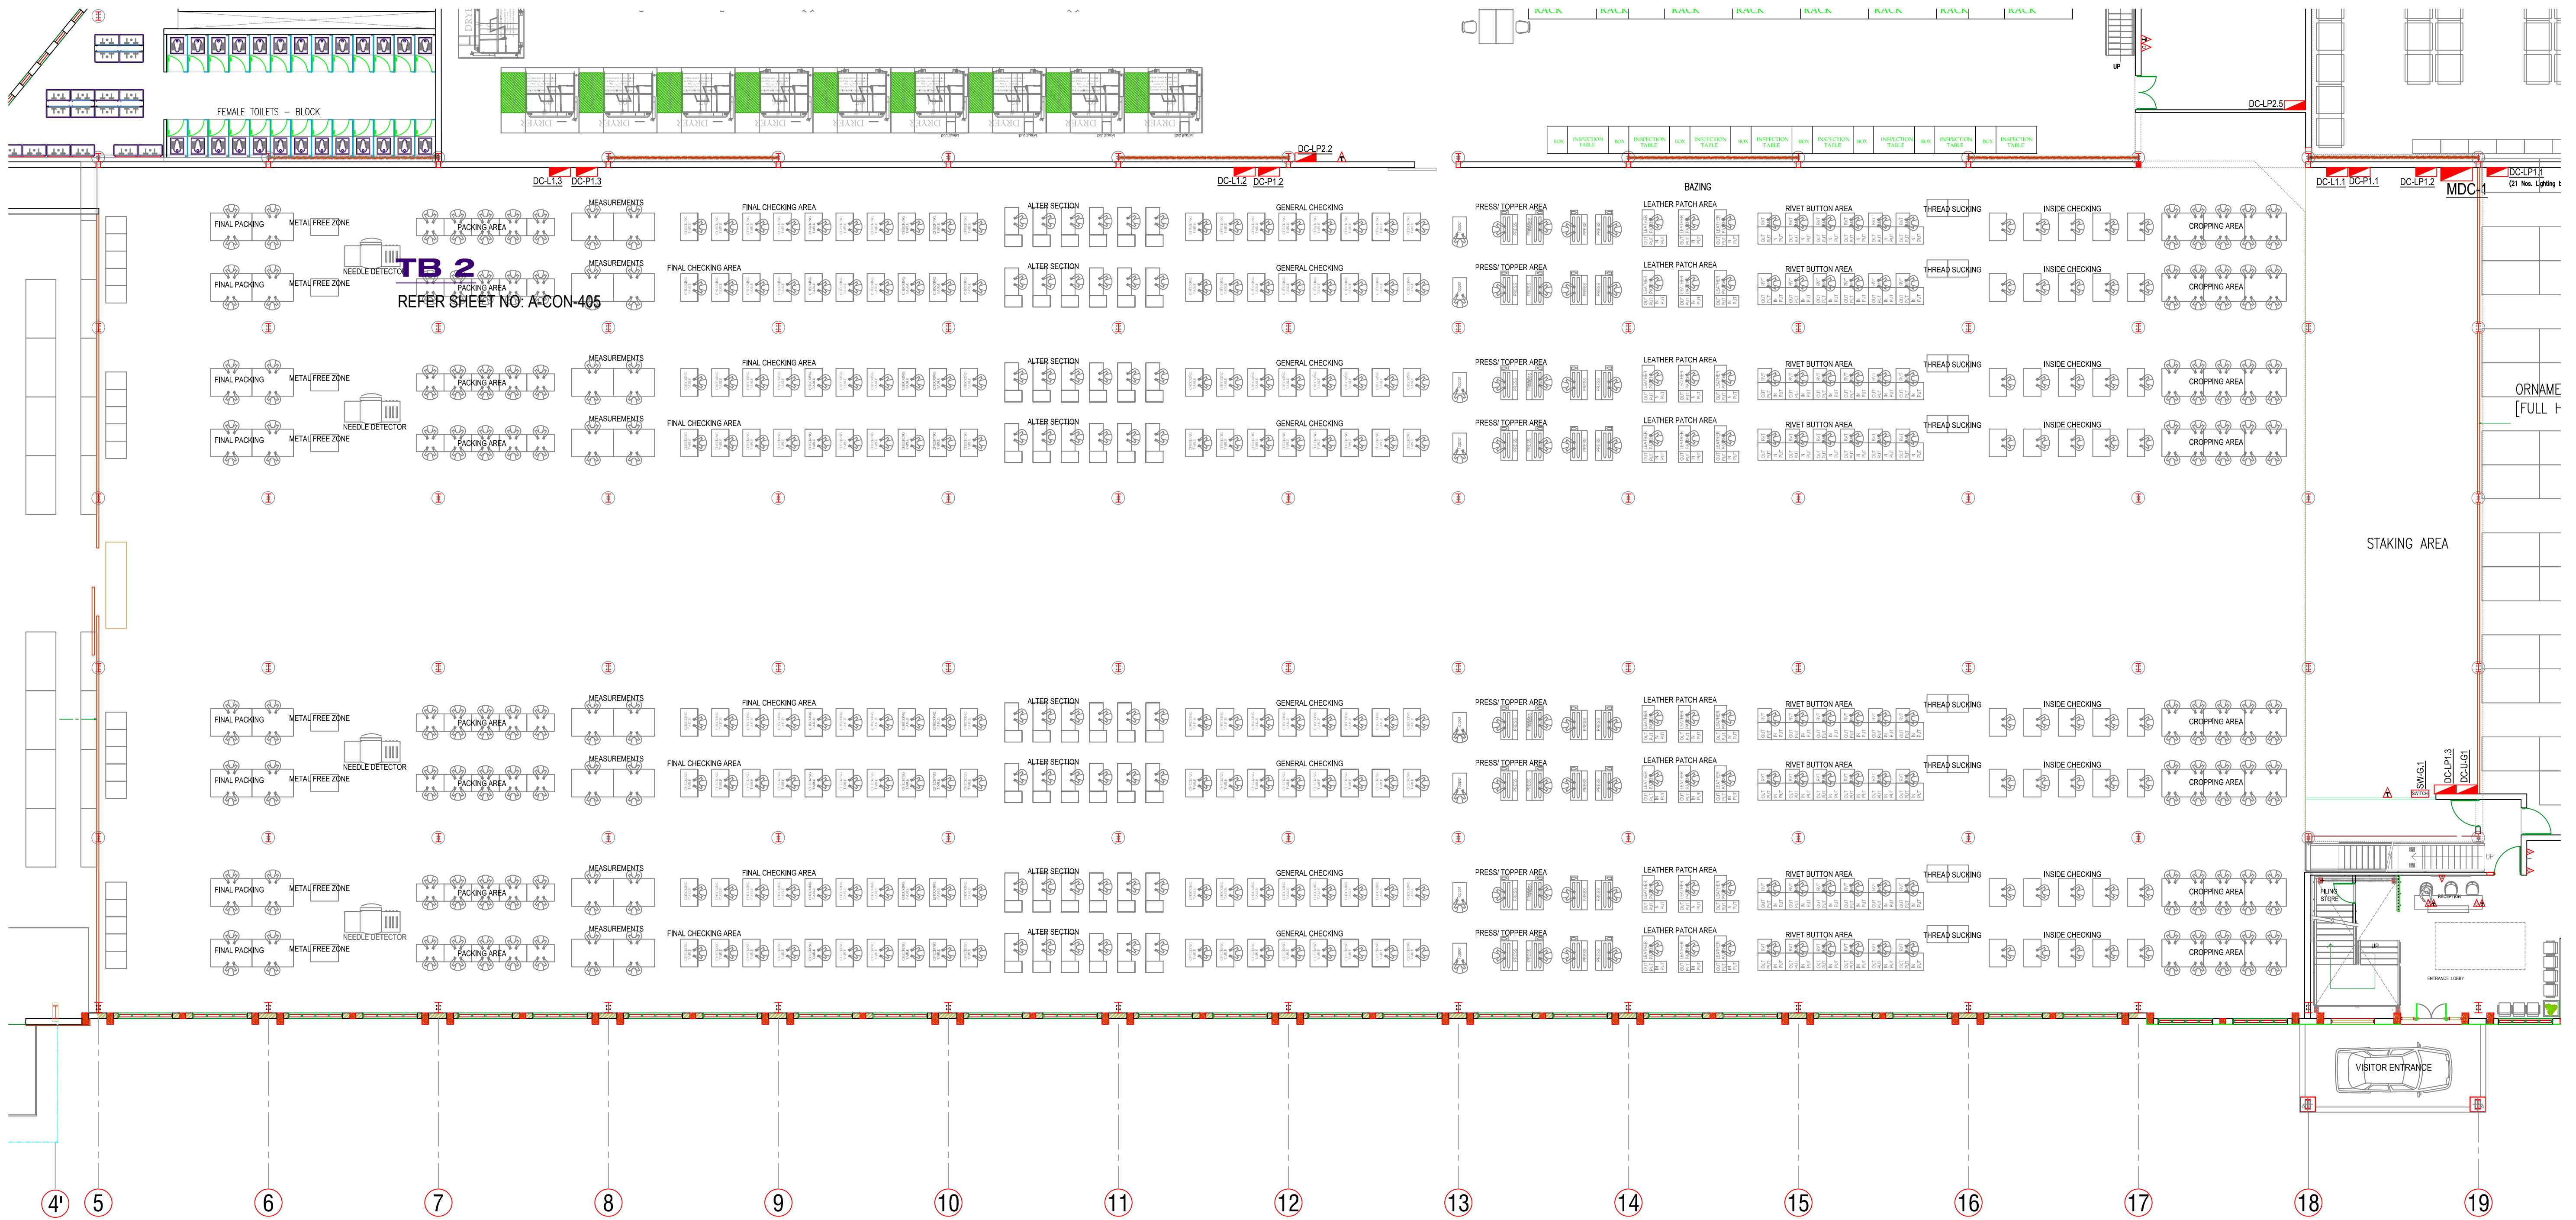

Project Title		Project Consultant						VERIFY ALL DIMENSIONS ON SITE BEFORE COMMENCING WORK COPYING OR THE REPRODUCTION OF THIS DRAWING IS STRICTLY PROHIBITED WITHOUT THE CONSENT OF NJ CONSULTANTS			
PROPOSED FACTORY FOR SOORTY TEXTILES (BD) LTD. PLOT NO 220-227, COMILLA EXPORT PROCESSING ZONE COMILLA - 3500, BANGLADESH		n j CONSULTANTS NJ CONSULTANTS 35A, 1/3, SUNETHRADEVI ROAD, KOHUWALA SRI LANKA TEL : 94-11-2814069, 94-11-4002365 FAX : 94-11-4002365 E-MAIL : noel@njcl.com						Drawing Title ELECTRICAL INSTALLATION GROUND FLOOR PLAN FINISHING AREA ELV LAYOUT		Drawn CADTEAM Date AUG 2013	
										Checked NJ Scale 1 : 150 @ A1	
										Approved Job No.	
										File Path	
										Dwg No. Revision	
				Rev.		Description		Date		Made By	
								Drawing Status		TENDER	
										E-G-FIN-ELV-100 R0	