


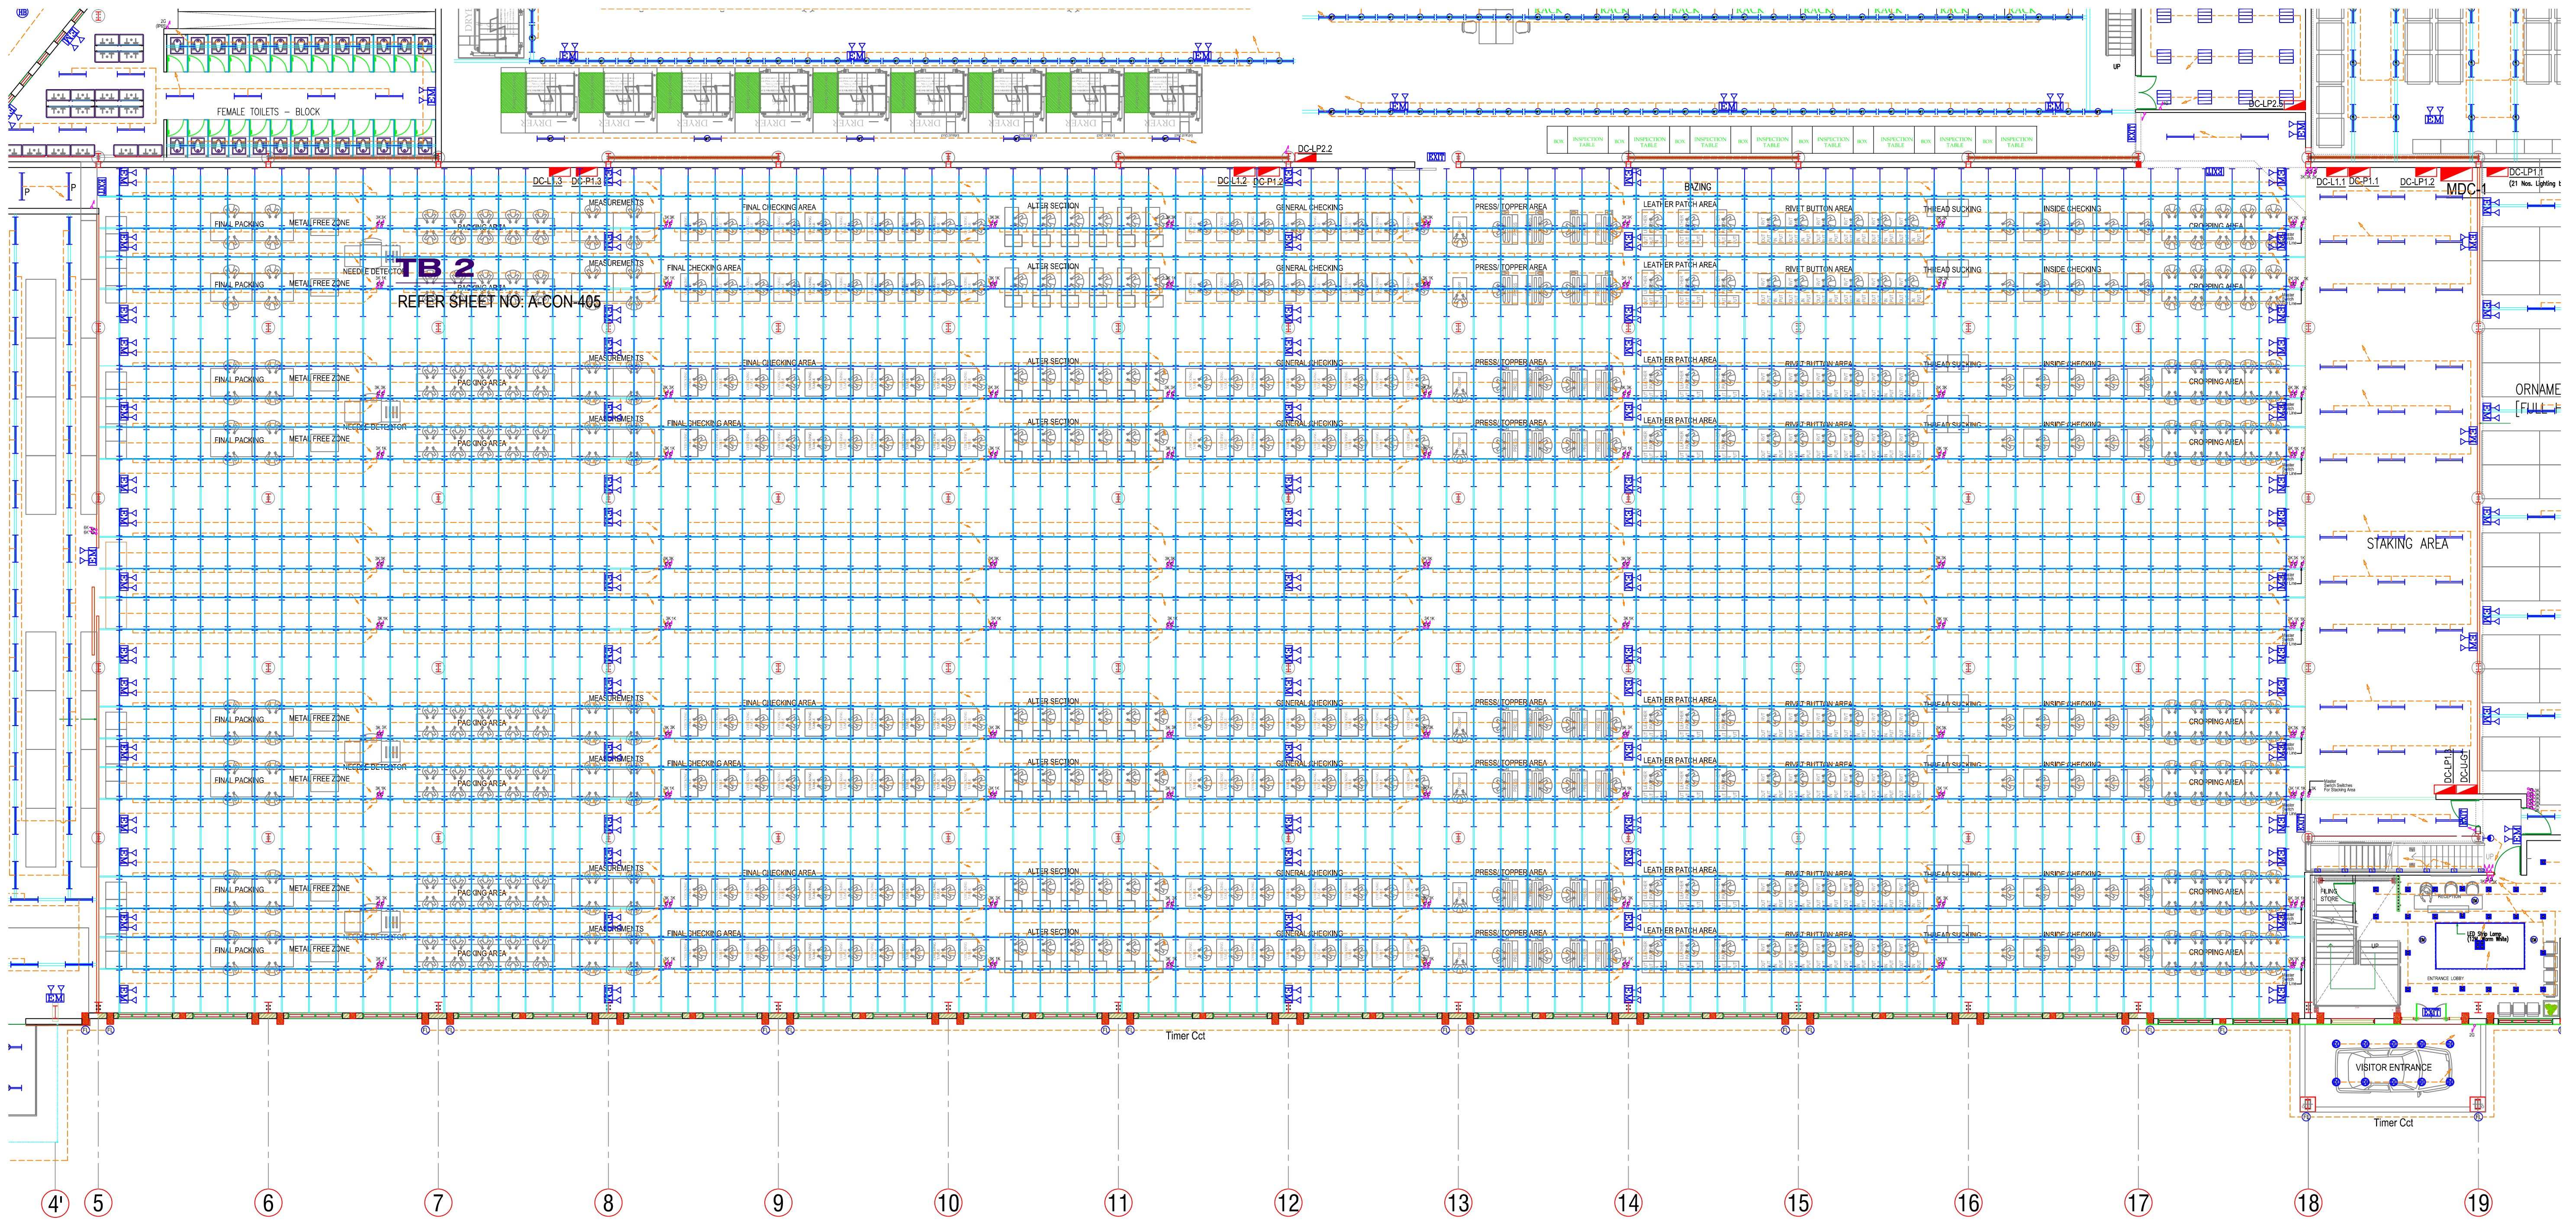

Project Title		Project Consultant				VERIFY ALL DIMENSIONS ON SITE BEFORE COMMENCING WORK COPYING OR THE REPRODUCTION OF THIS DRAWING IS STRICTLY PROHIBITED WITHOUT THE CONSENT OF NJ CONSULTANTS			
PROPOSED FACTORY FOR SOORTY TEXTILES (BD) LTD. PLOT NO 220-227, COMILLA EXPORT PROCESSING ZONE COMILLA - 3500, BANGLADESH		 NJ CONSULTANTS 35A, 1/3, SUNETHRADEVI ROAD, KOHUWALA SRI LANKA TEL : 94-11-2814069, 94-11-4002365 FAX : 94-11-4002365 E-MAIL : noel@njcl.com				Drawing Title		Drawn CADTEAM Date AUG 2013	
						ELECTRICAL INSTALLATION GROUND FLOOR PLAN FINISHING AREA LIGHTING LAYOUT		Checked NJ Scale 1 : 150 @ A1	
						Drawing Status		Approved Job No.	
						TENDER		File Path	
								Dwg No. Revision	
				Rev.		Description		Date Made By	
								E-G-FIN-L-100 R0	