


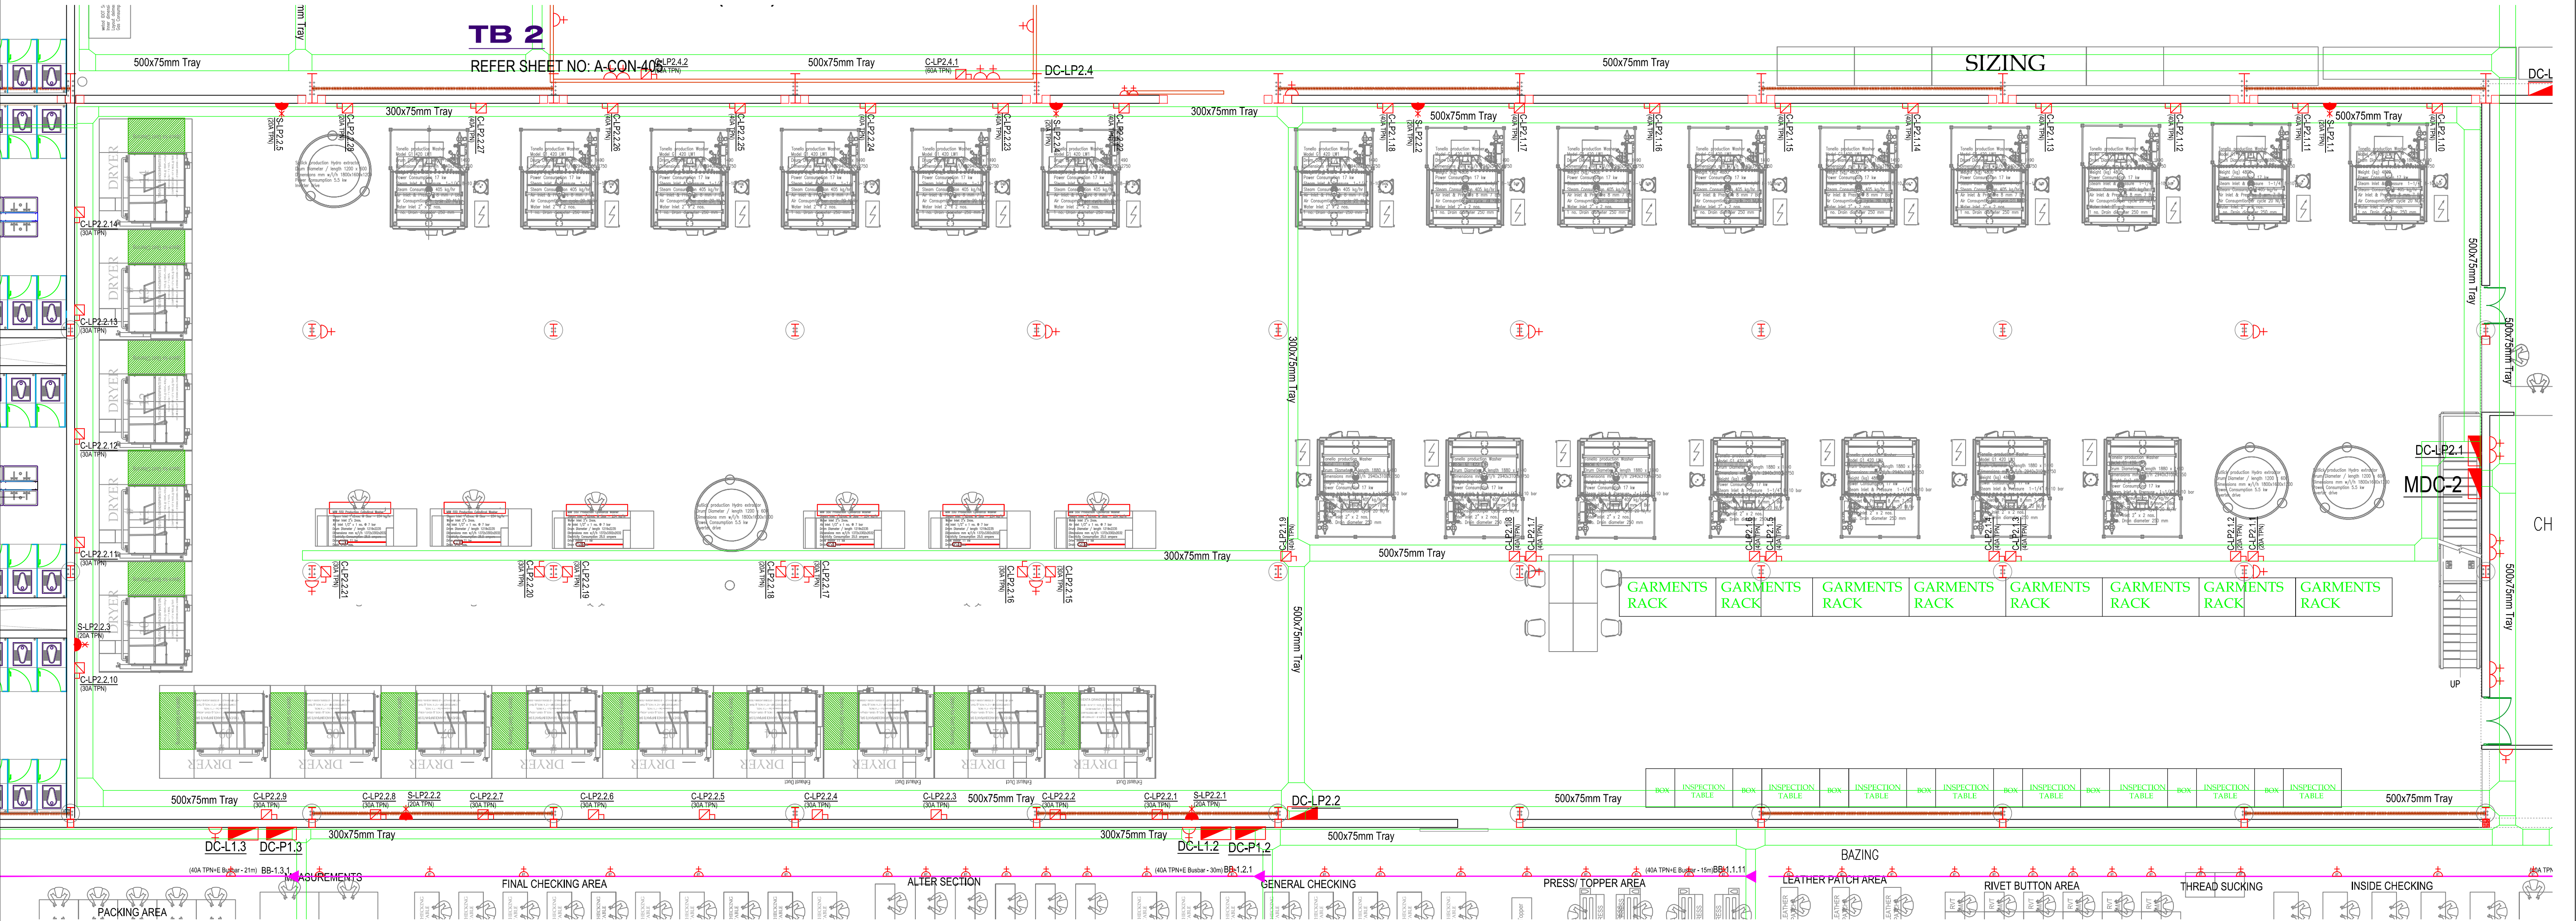

Project Title		Project Consultant								VERIFY ALL DIMENSIONS ON SITE BEFORE COMMENCING WORK COPYING OR THE REPRODUCTION OF THIS DRAWING IS STRICTLY PROHIBITED WITHOUT THE CONSENT OF NJ CONSULTANTS			
PROPOSED FACTORY FOR SOORTY TEXTILES (BD) LTD. PLOT NO 220-227, COMILLA EXPORT PROCESSING ZONE COMILLA - 3500, BANGLADESH		 NJ CONSULTANTS 35A, 1/3, SUNETHRADEVI ROAD, KOHUWALA SRI LANKA TEL : 94-11-2814069, 94-11-4002365 FAX : 94-11-4002365 E-MAIL : noel@njcdk.com								Drawing Title ELECTRICAL INSTALLATION GROUND FLOOR PLAN WASHING PLANT AREA		Drawn CADTEAM Date AUG 2013	
												Checked NJ Scale 1 : 100 @ A1	
												Approved Job No.	
												File Path	
												Dwg No. Revision	
								Drawing Status TENDER		E-G-WP-100 R0			
				Rev.		Description		Date		Made By			