




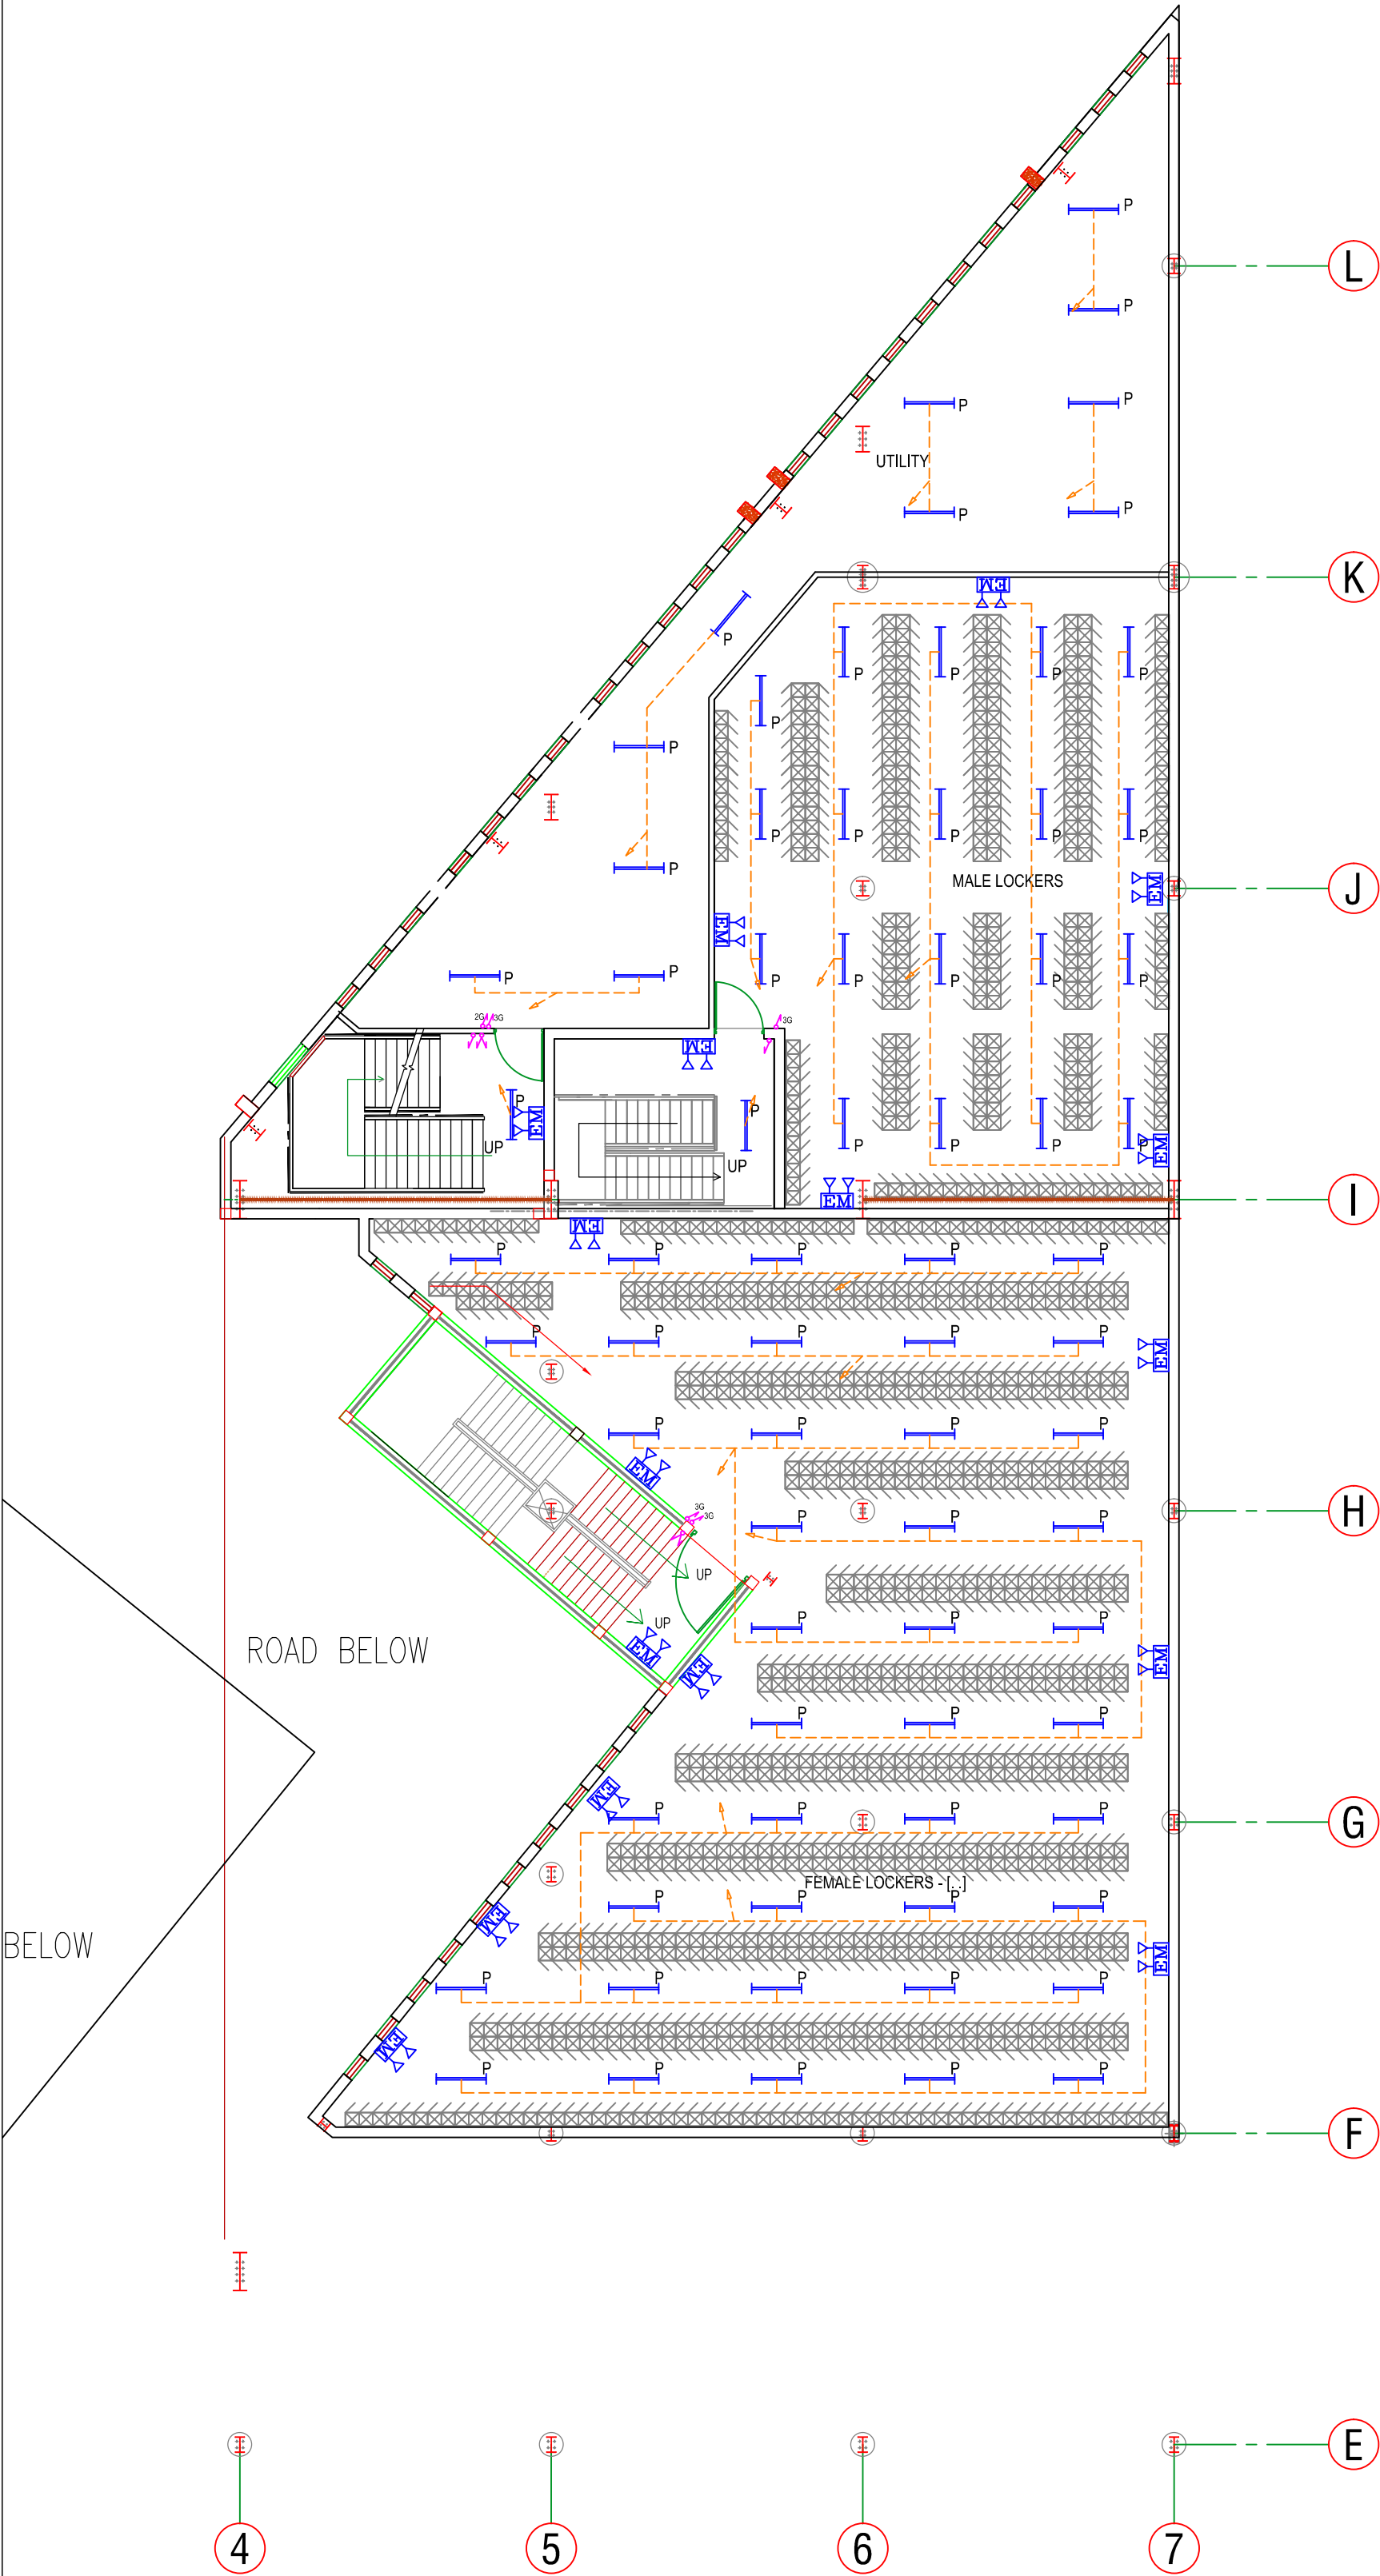

**LOCKER ROOM
PLAN**

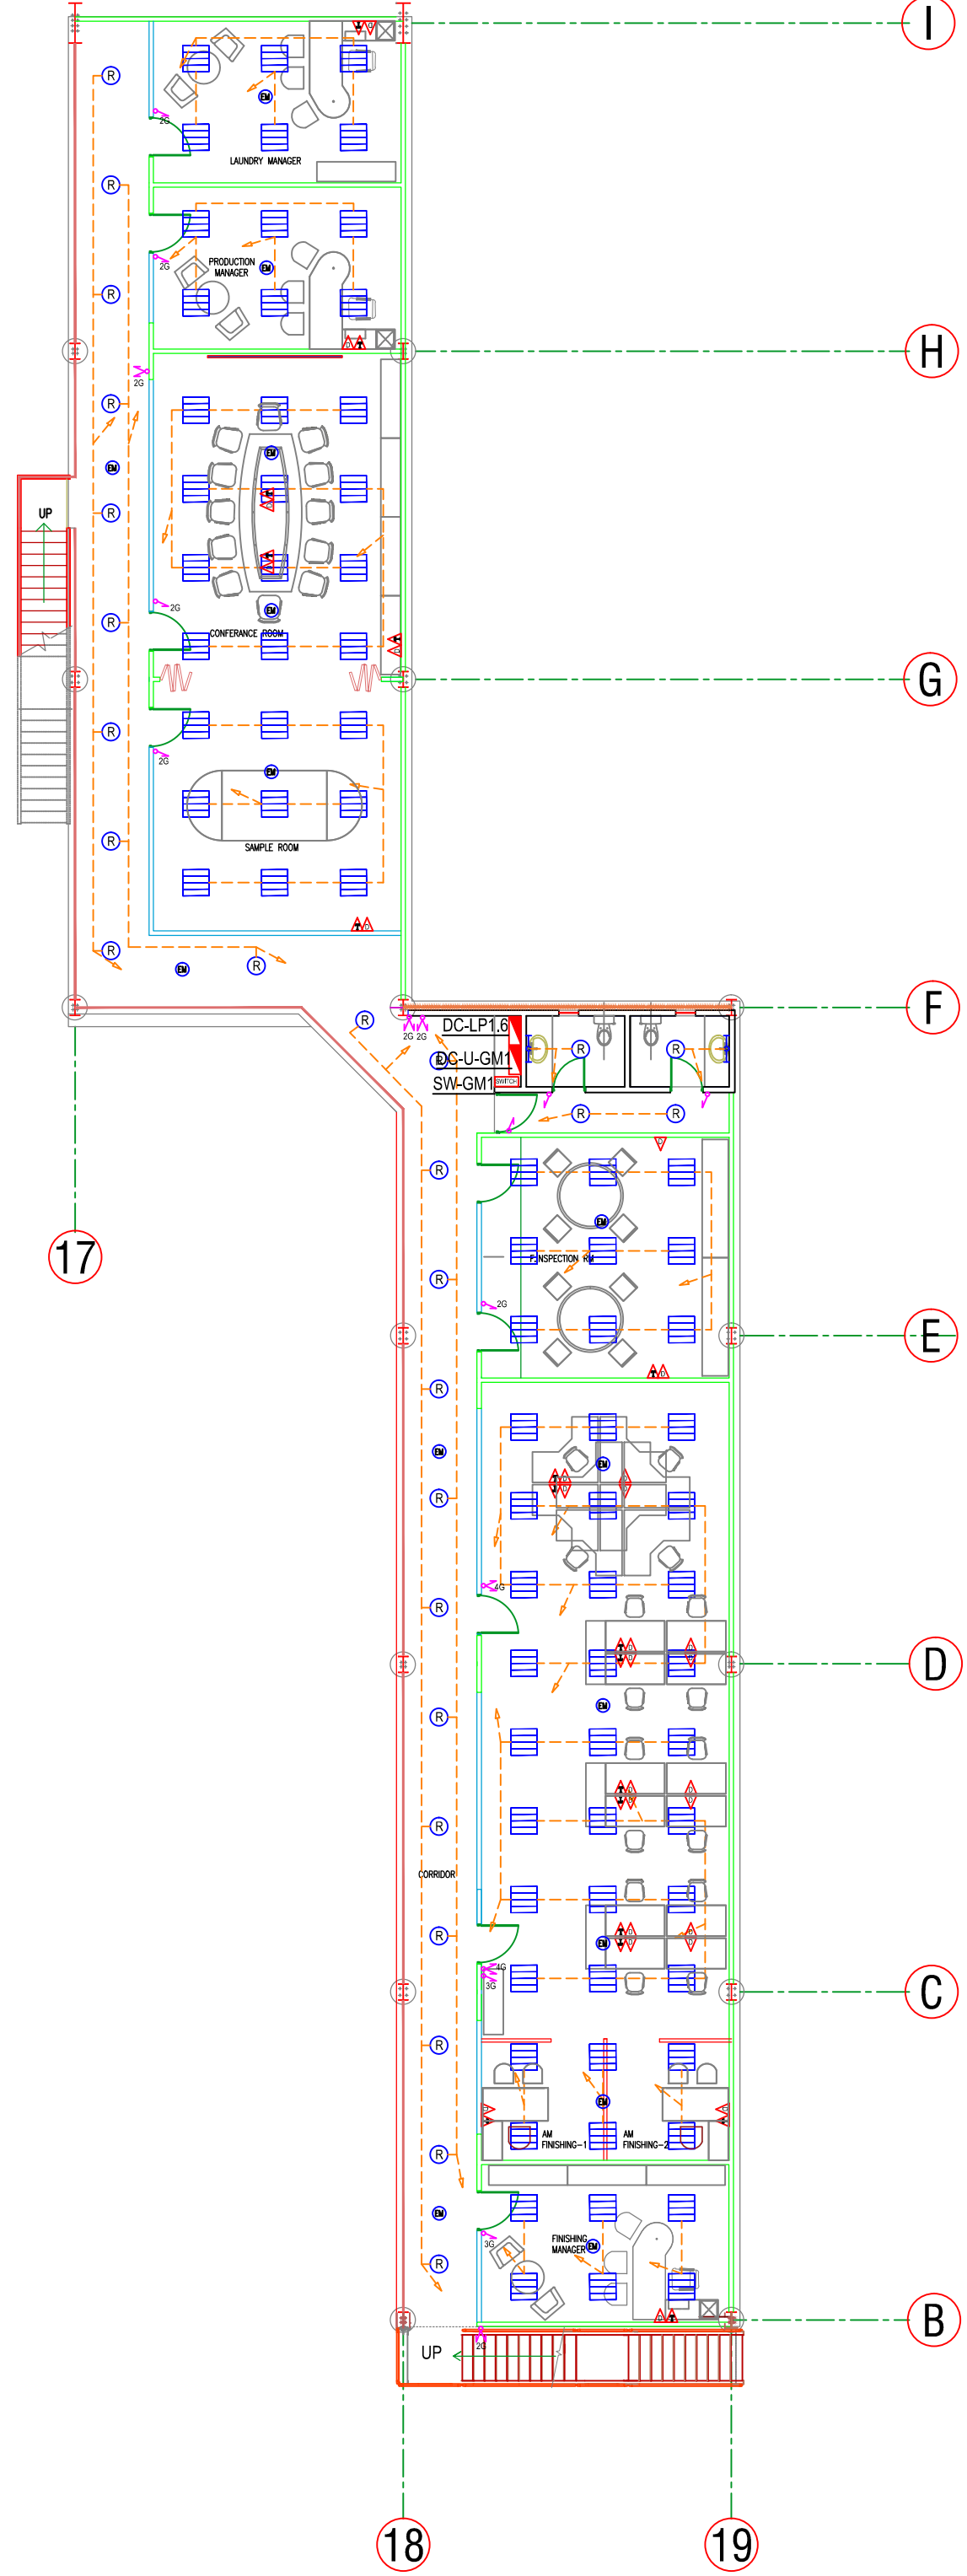

MEZZANINE FLOOR - G1
(ABOVE STACKING AREA)

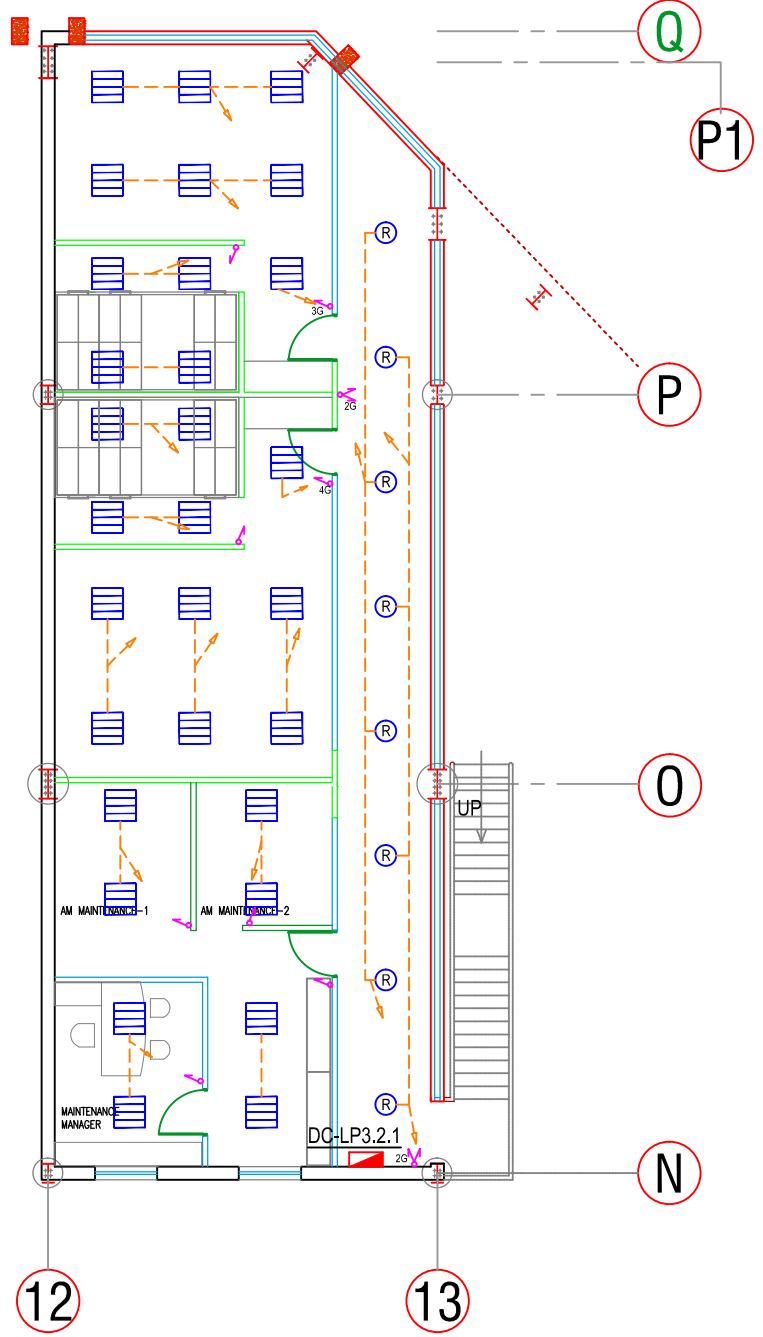

MEZZANINE FLOOR PLAN - G3

Project Title		Project Consultant						VERIFY ALL DIMENSIONS ON SITE BEFORE COMMENCING WORK COPYING OR THE REPRODUCTION OF THIS DRAWING IS STRICTLY PROHIBITED WITHOUT THE CONSENT OF NJ CONSULTANTS	
PROPOSED FACTORY FOR SOORTY TEXTILES (BD) LTD. PLOT NO 220-227, COMILLA EXPORT PROCESSING ZONE COMILLA - 3500, BANGLADESH		 NJ CONSULTANTS 35A, 113, SUNETHRADEVI ROAD, KORUWALA SRI LANKA TEL : 94-11-2814069, 94-11-4002365 FAX : 94-11-4002365 E-MAIL : noel@njclk.com						Drawing Title	Drawn CADTEAM Date AUG 2013
								ELECTRICAL INSTALLATION GROUND FLOOR MEZZANINE PLAN LIGHTING & POWER	Checked NJ Scale 1 : 50 @ A1
								Drawing Status	Approved Job No.
									File Path
				Rev.	Description	Date	Made By	Dwg No.	Revision
								E-GM-L-101	R0