




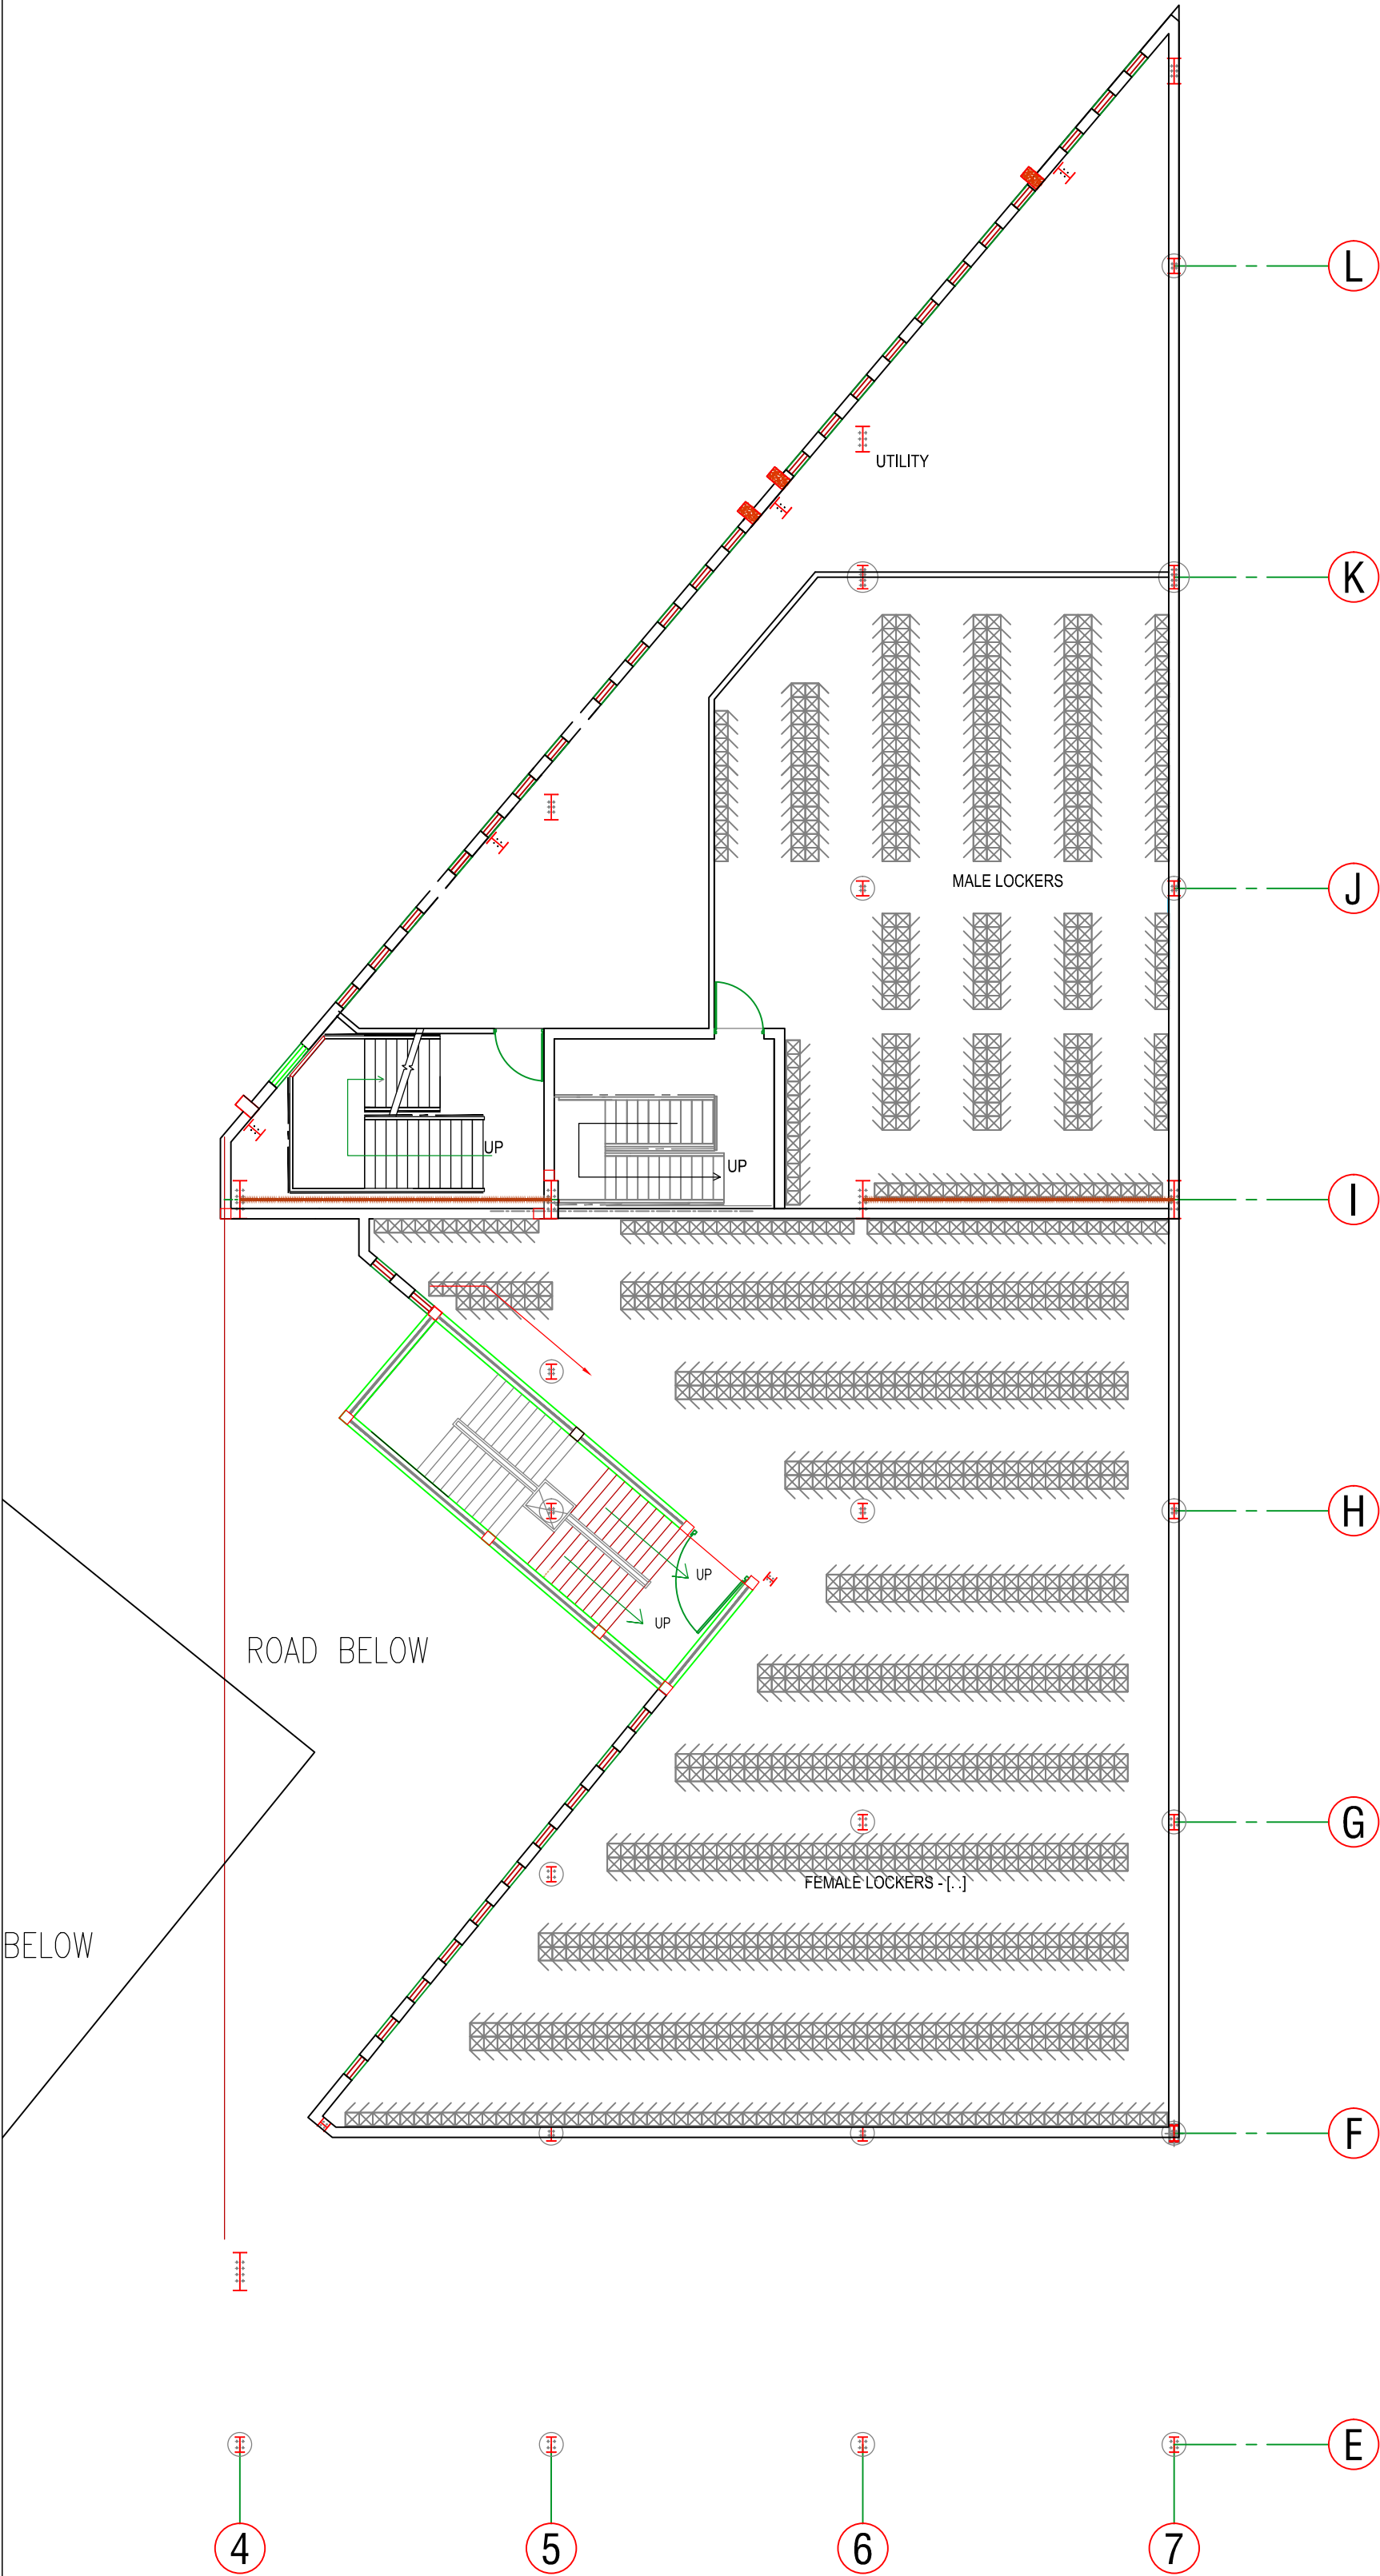

LOCKER ROOM
PLAN

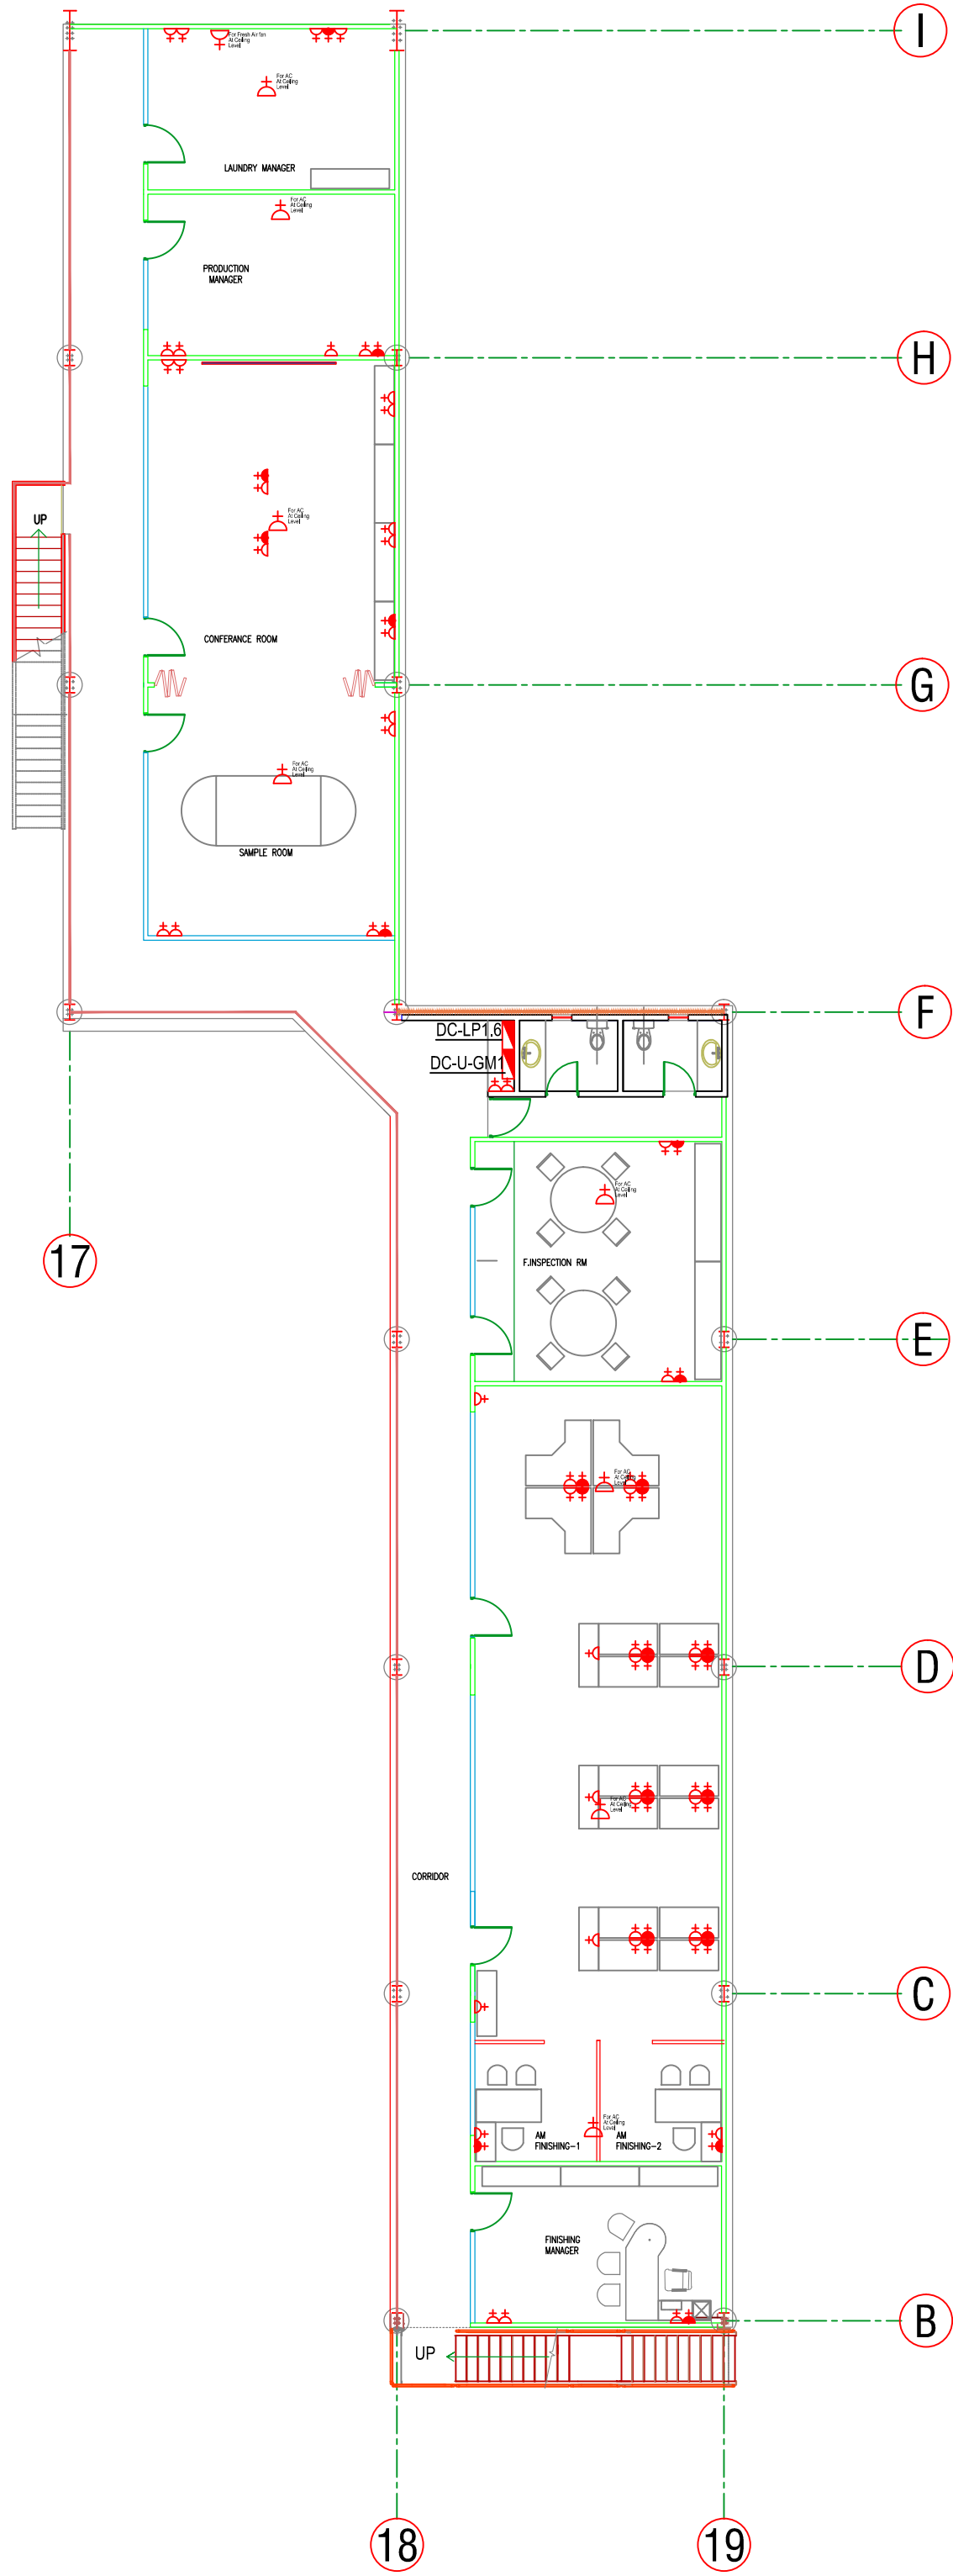

MEZZANINE FLOOR - G1
(ABOVE STACKING AREA)

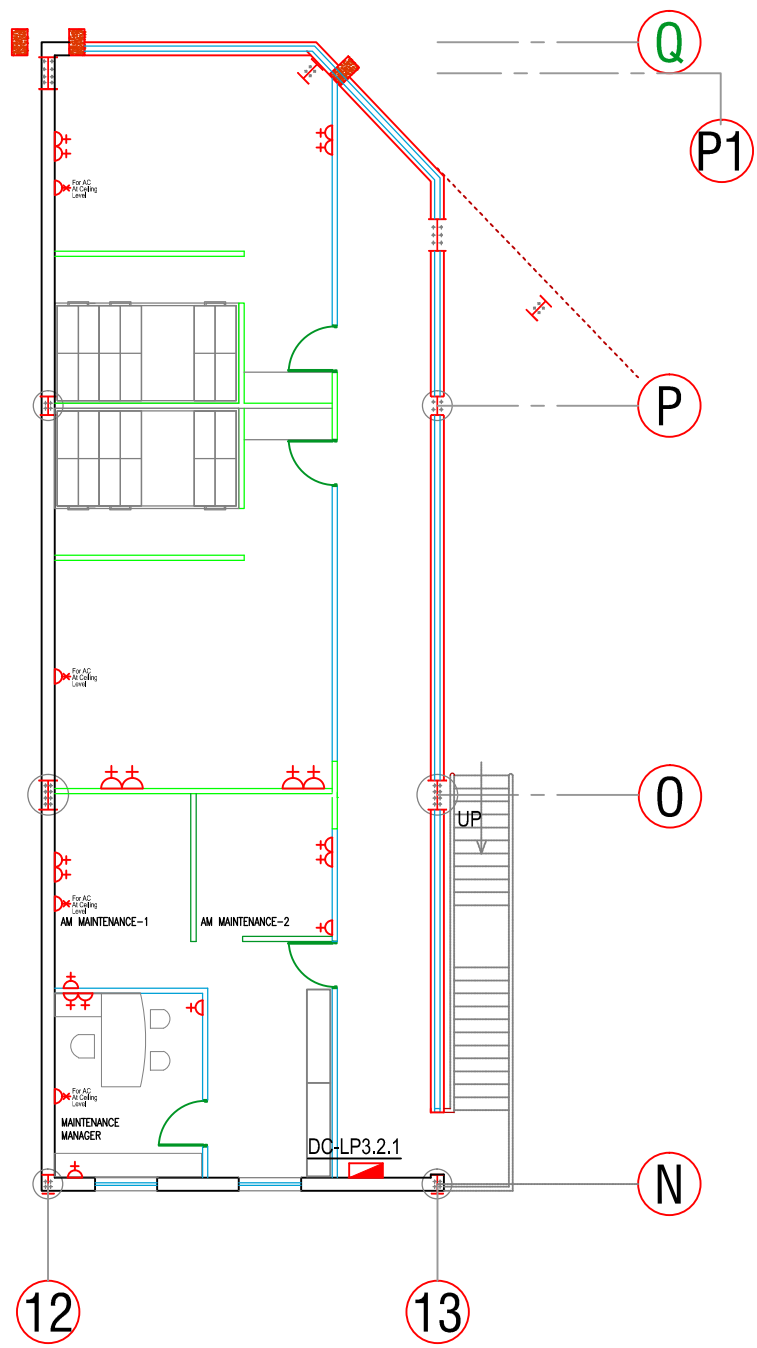

MEZZANINE FLOOR PLAN - G3

Project Title		Project Consultant						VERIFY ALL DIMENSIONS ON SITE BEFORE COMMENCING WORK COPYING OR THE REPRODUCTION OF THIS DRAWING IS STRICTLY PROHIBITED WITHOUT THE CONSENT OF NJ CONSULTANTS	
PROPOSED FACTORY FOR SOORTY TEXTILES (BD) LTD. PLOT NO 220-227, COMILLA EXPORT PROCESSING ZONE COMILLA - 3500, BANGLADESH		 NJ CONSULTANTS 35A, 113, SUNETHRADEVI ROAD, KOHUWALA SRI LANKA TEL : 94-11-2814069, 94-11-4002365 FAX : 94-11-4002365 E-MAIL : noel@njclk.com						Drawing Title	
								ELECTRICAL INSTALLATION GROUND FLOOR MEZZANINE PLAN POWER LAYOUT	
								Drawing Status	
								TENDER	
Rev.		Description		Date		Made By		Dwg No.	
								E-GM-P-101	
								Revision	
								R0	
								Drawn	
								CADTEAM	
								Date	
								AUG 2013	
								Checked	
								NJ	
								Scale	
								1 : 50 @ A1	
								Approved	
								Job No.	
								File Path	
								Dwg No.	