


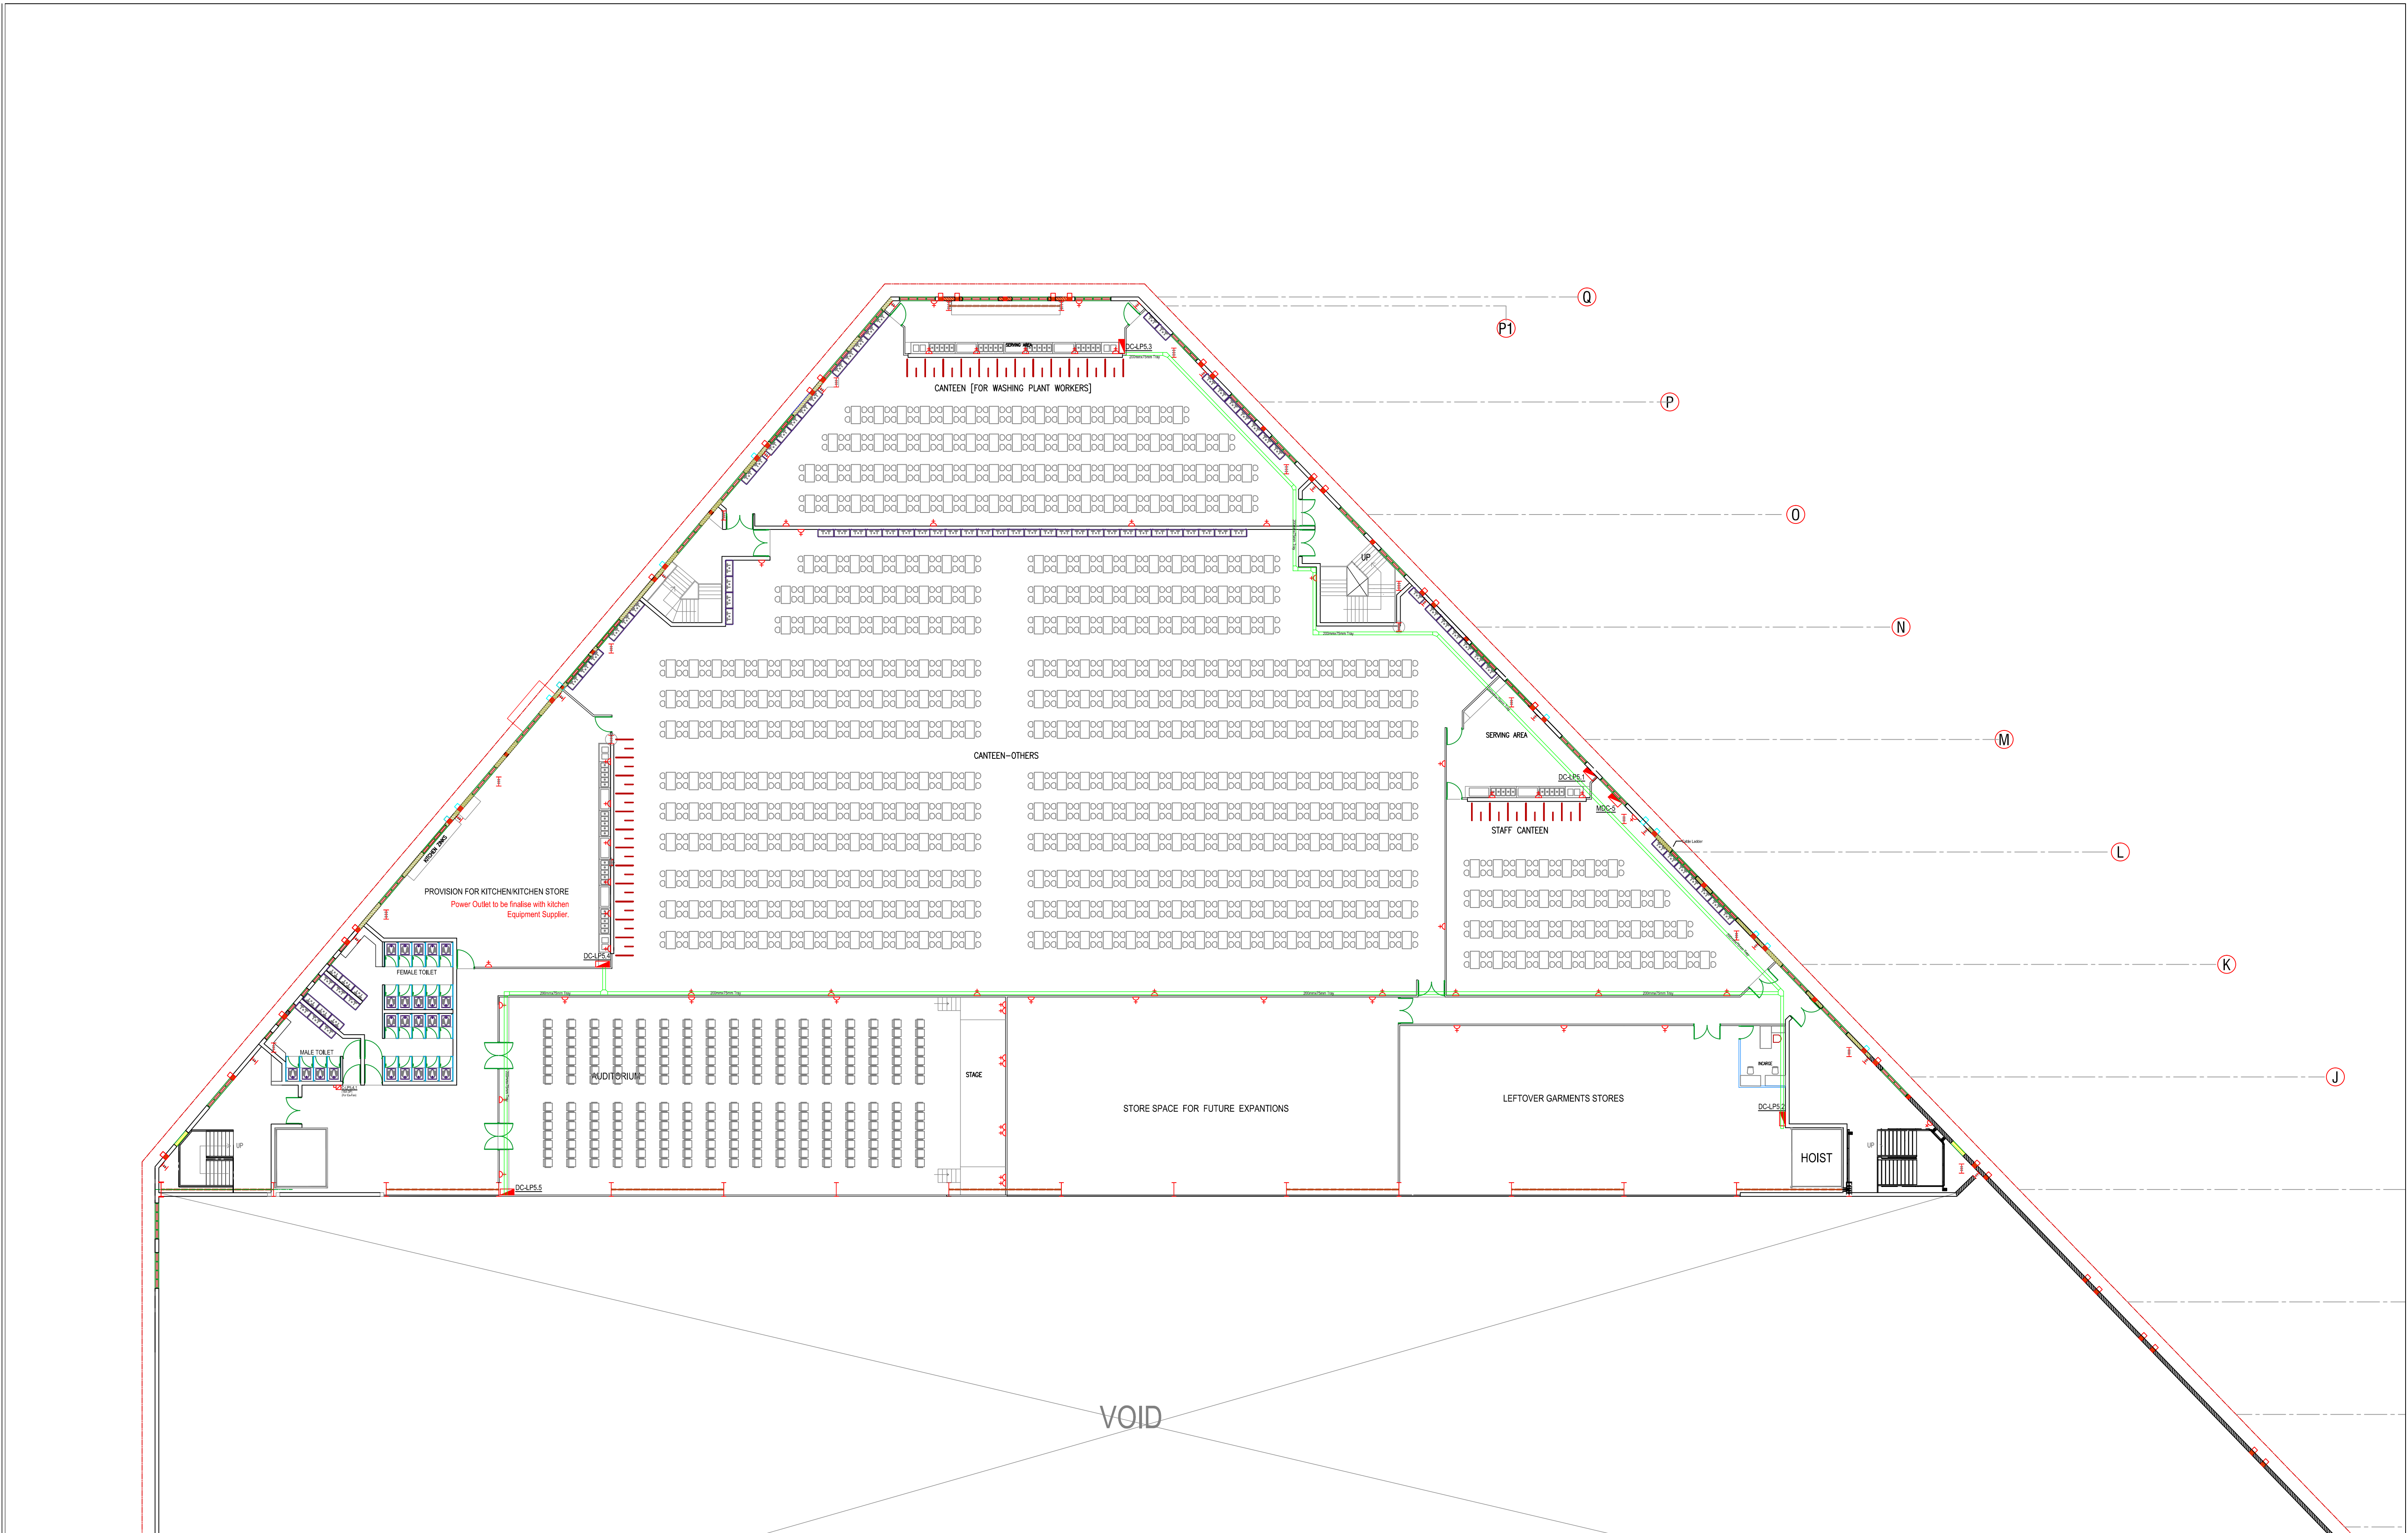

Project Title	Project Consultant						VERIFY ALL DIMENSIONS ON SITE BEFORE COMMENCING WORK COPYING OR THE REPRODUCTION OF THIS DRAWING IS STRICTLY PROHIBITED WITHOUT THE CONSENT OF NJ CONSULTANTS		
PROPOSED FACTORY FOR SOORTY TEXTILES (BD) LTD. PLOT NO 220-227, COMILLA EXPORT PROCESSING ZONE COMILLA - 3500, BANGLADESH	 NJ CONSULTANTS 35A, 1/3, SUNETHRADEVI ROAD, KOHUWALA SRI LANKA TEL : 94-11-2814069, 94-11-4002365 FAX : 94-11-4002365 E-MAIL : noel@njck.com						Drawing Title	Drawn CADTEAM Date OCT 2013	
								ELECTRICAL INSTALLATION SECOND FLOOR POWER LAYOUT	Checked NJ Scale 1 : 250 @ A1
									Approved Job No.
								File Path	
								Dwg No.	Revision
	Rev.	Description	Date	Made By		Drawing Status	TENDER	E-S-P-100 R0	