




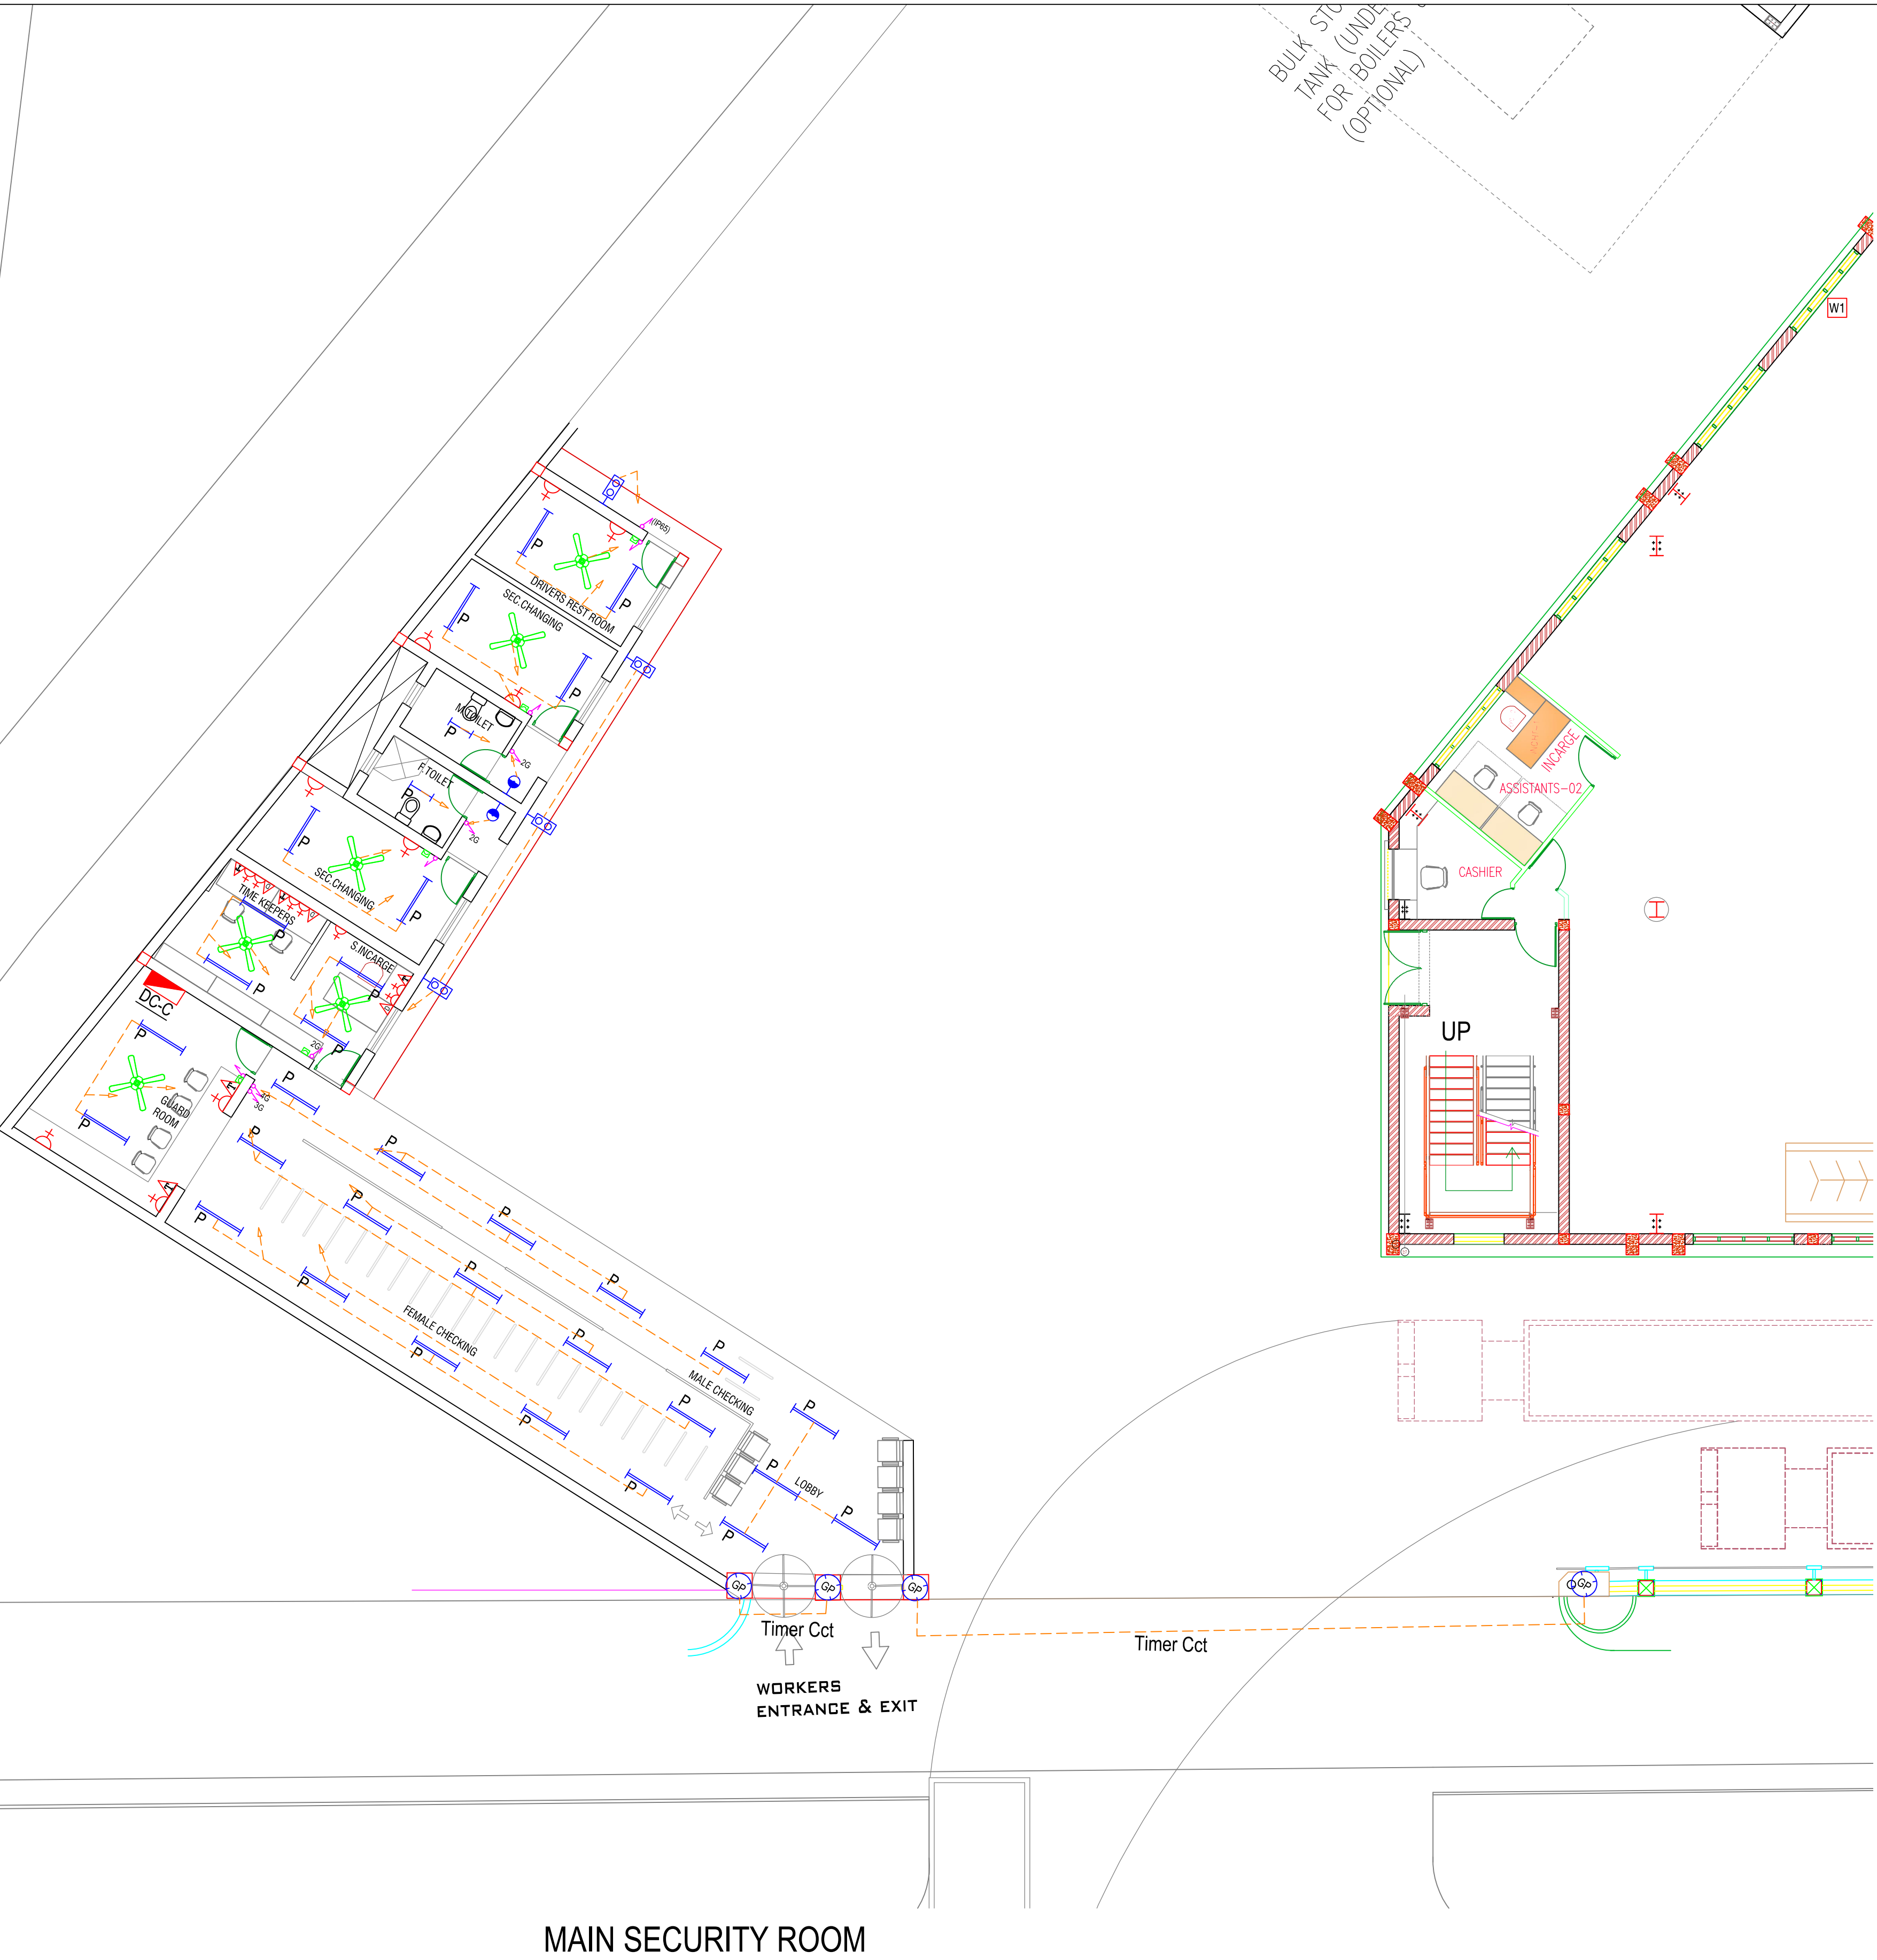

MAIN SECURITY ROOM

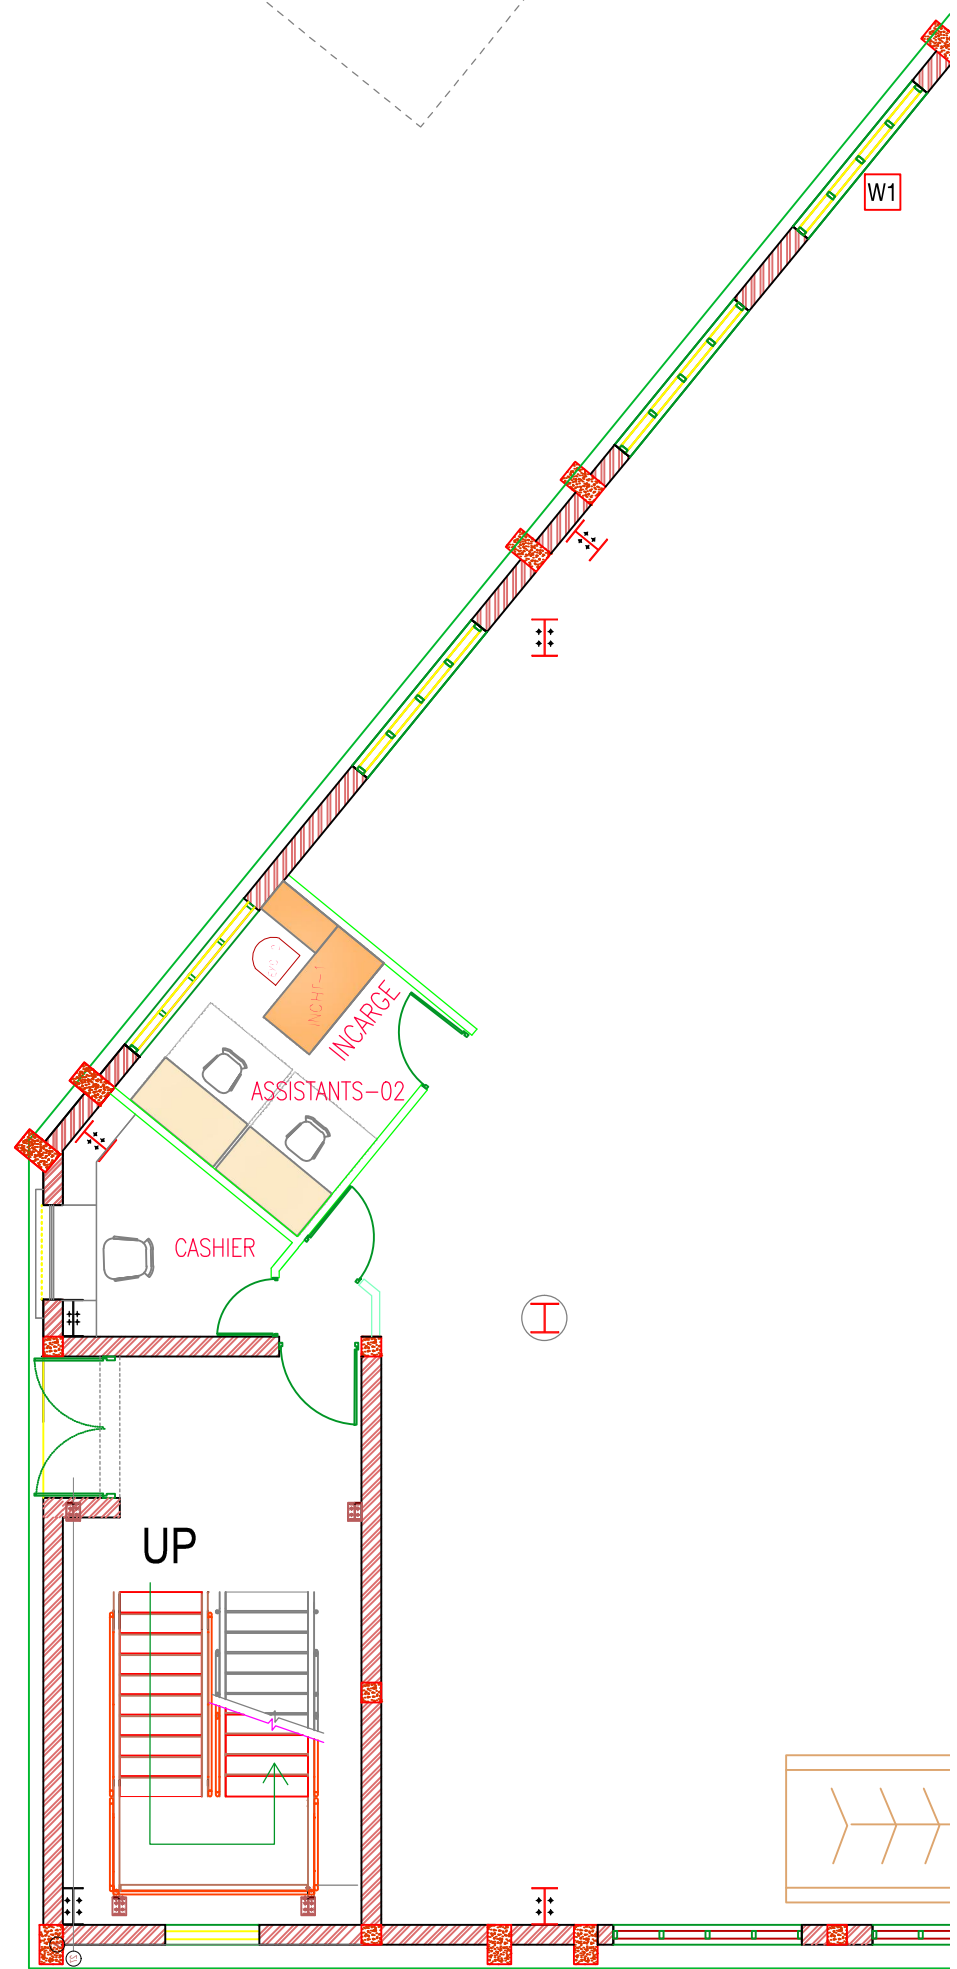

SECURITY ROOM - 02

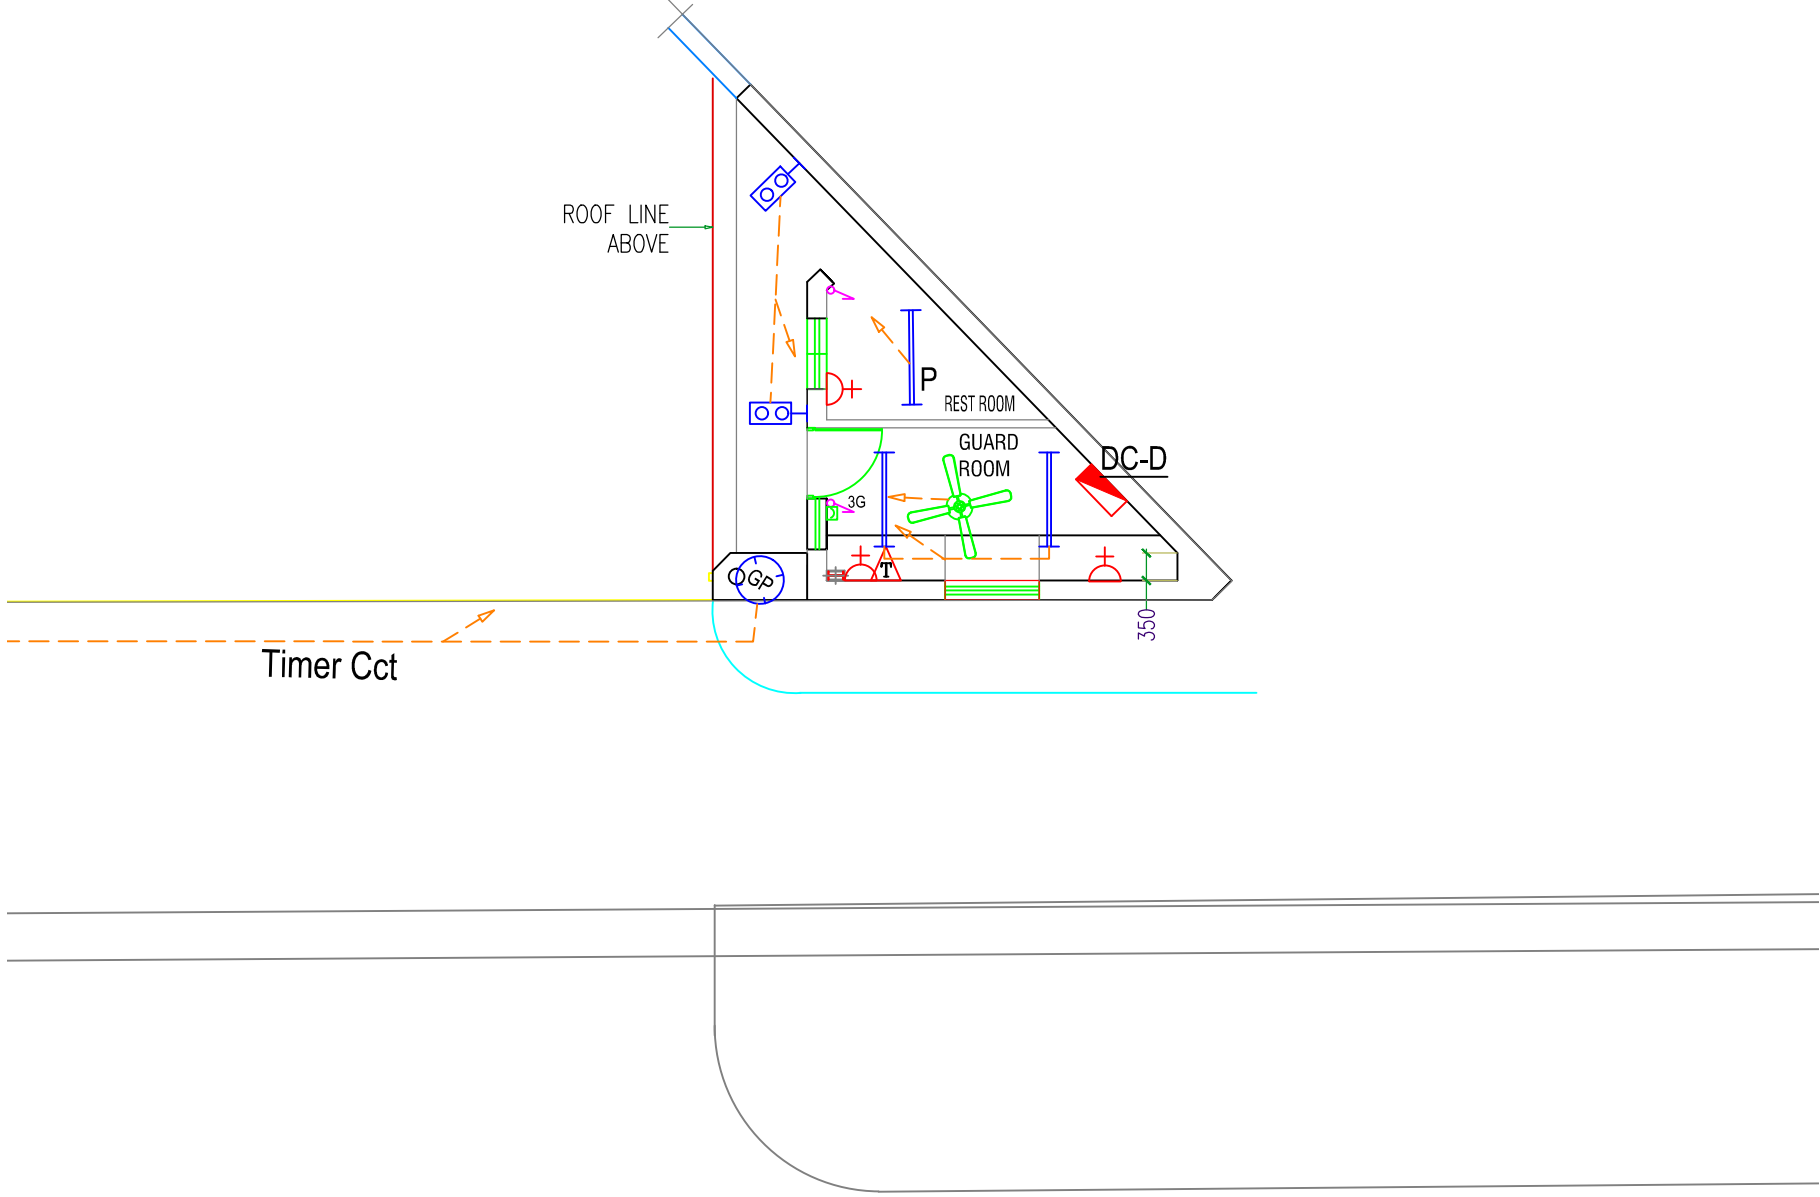

Project Title	Project Consultant					VERIFY ALL DIMENSIONS ON SITE BEFORE COMMENCING WORK COPYING OR THE REPRODUCTION OF THIS DRAWING IS STRICTLY PROHIBITED WITHOUT THE CONSENT OF NJ CONSULTANTS	
PROPOSED FACTORY FOR SOORTY TEXTILES (BD) LTD. PLOT NO 220-227, COMILLA EXPORT PROCESSING ZONE COMILLA - 3500, BANGLADESH	 NJ CONSULTANTS 35A, 1/3, SUNETHRADEVI ROAD, KOHLUWALA SRI LANKA TEL : 94-11-2814069, 94-11-4002365 FAX : 94-11-4002365 E-MAIL : noel@njcslk.com					Drawing Title	Drawn CADTEAM Date OCT 2013 Checked NJ Scale 1 : 100 @ A1 Approved Job No. File Path Dwg No. Revision
						ELECTRICAL INSTALLATION SECURITY ROOMS LIGHTING, POWER LAYOUT	
						Drawing Status	TENDER
		Rev.	Description	Date	Made By		E-SEC-101 R0