


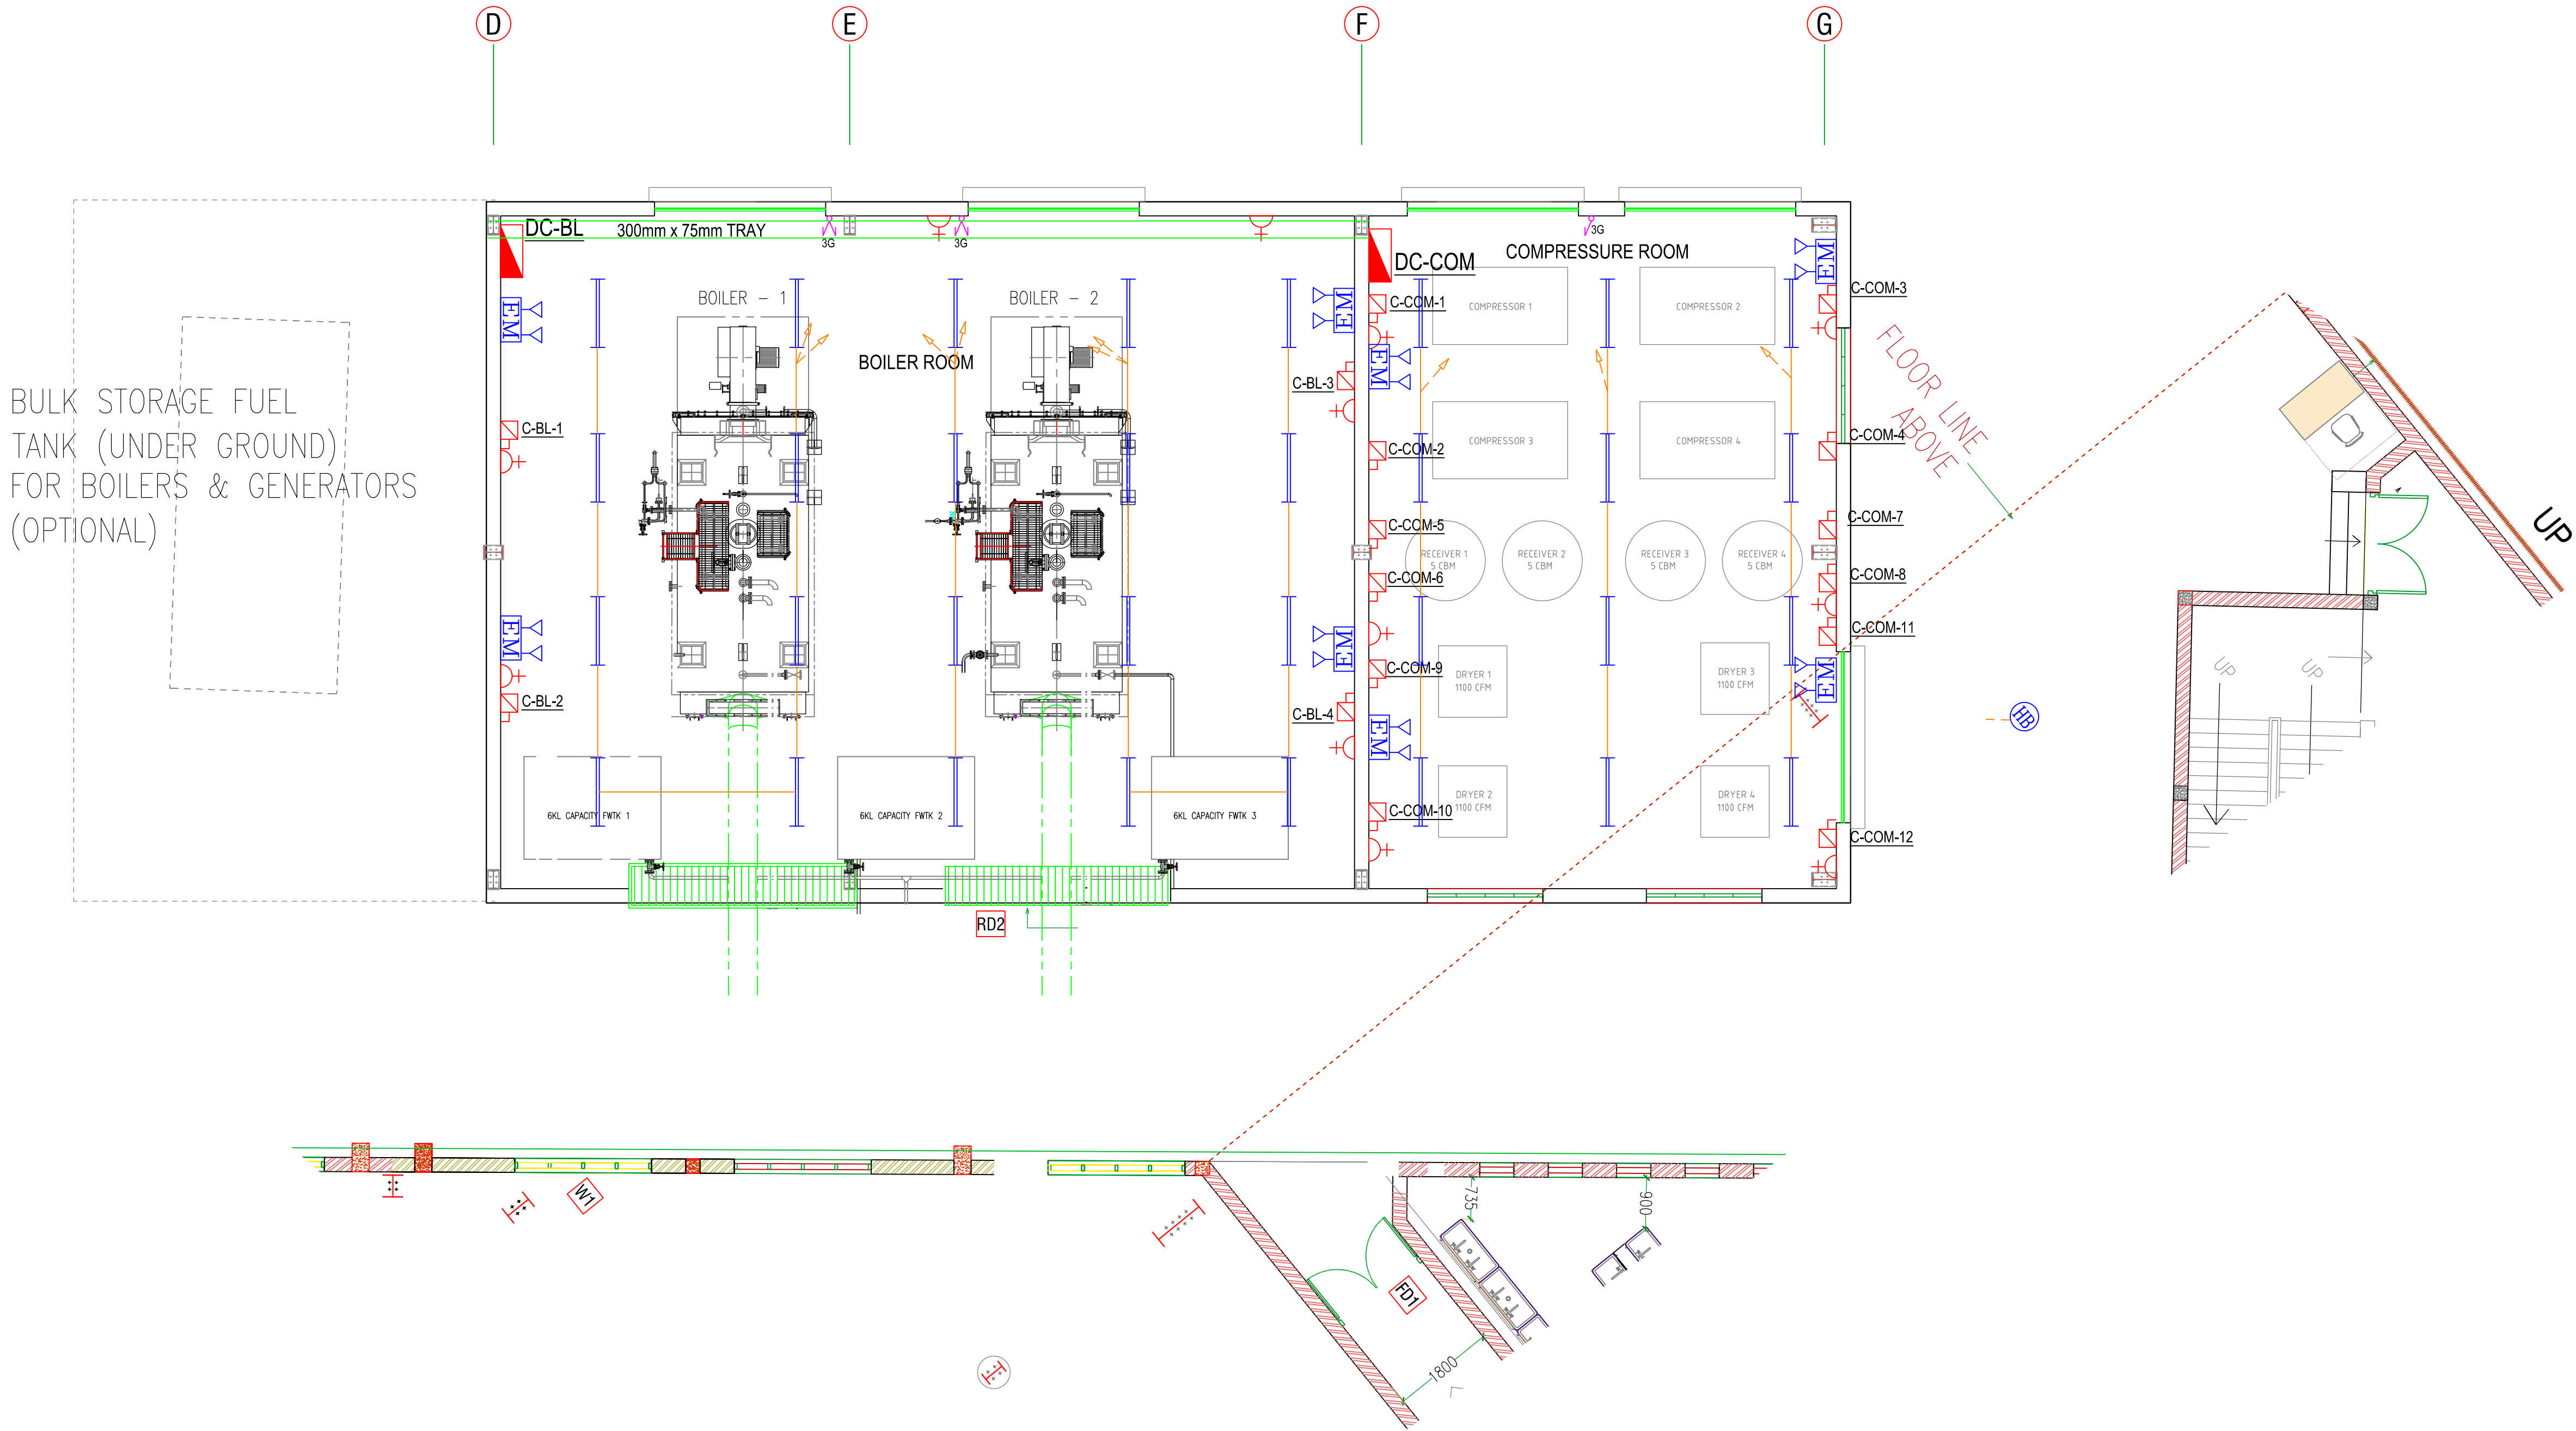

Project Title	Project Consultant					VERIFY ALL DIMENSIONS ON SITE BEFORE COMMENCING WORK COPYING OR THE REPRODUCTION OF THIS DRAWING IS STRICTLY PROHIBITED WITHOUT THE CONSENT OF NJ CONSULTANTS	
PROPOSED FACTORY FOR SOORTY TEXTILES (BD) LTD. PLOT NO 220-227, COMILLA EXPORT PROCESSING ZONE COMILLA - 3500, BANGLADESH	n CONSULTANTS 35A, 1/3, SUNETHRADEVI ROAD, KOHUWALA SRI LANKA TEL : 94-11-2814069, 94-11-4002365 FAX : 94-11-4002365 E-MAIL : noel@njcl.com NJ CONSULTANTS <td></td> <td></td> <td></td> <td></td> <td>Drawing Title</td> <td>Drawn CADTEAM Date OCT 2013</td>					Drawing Title	Drawn CADTEAM Date OCT 2013
						ELECTRICAL INSTALLATION SERVICE BUILDING - 1 LIGHTING, POWER LAYOUT	Checked NJ Scale 1 : 75 @ A1
							Approved Job No.
							File Path
							Dwg No. Revision
		Rev.	Description	Date	Made By	Drawing Status TENDER	E-SER-101 R0