
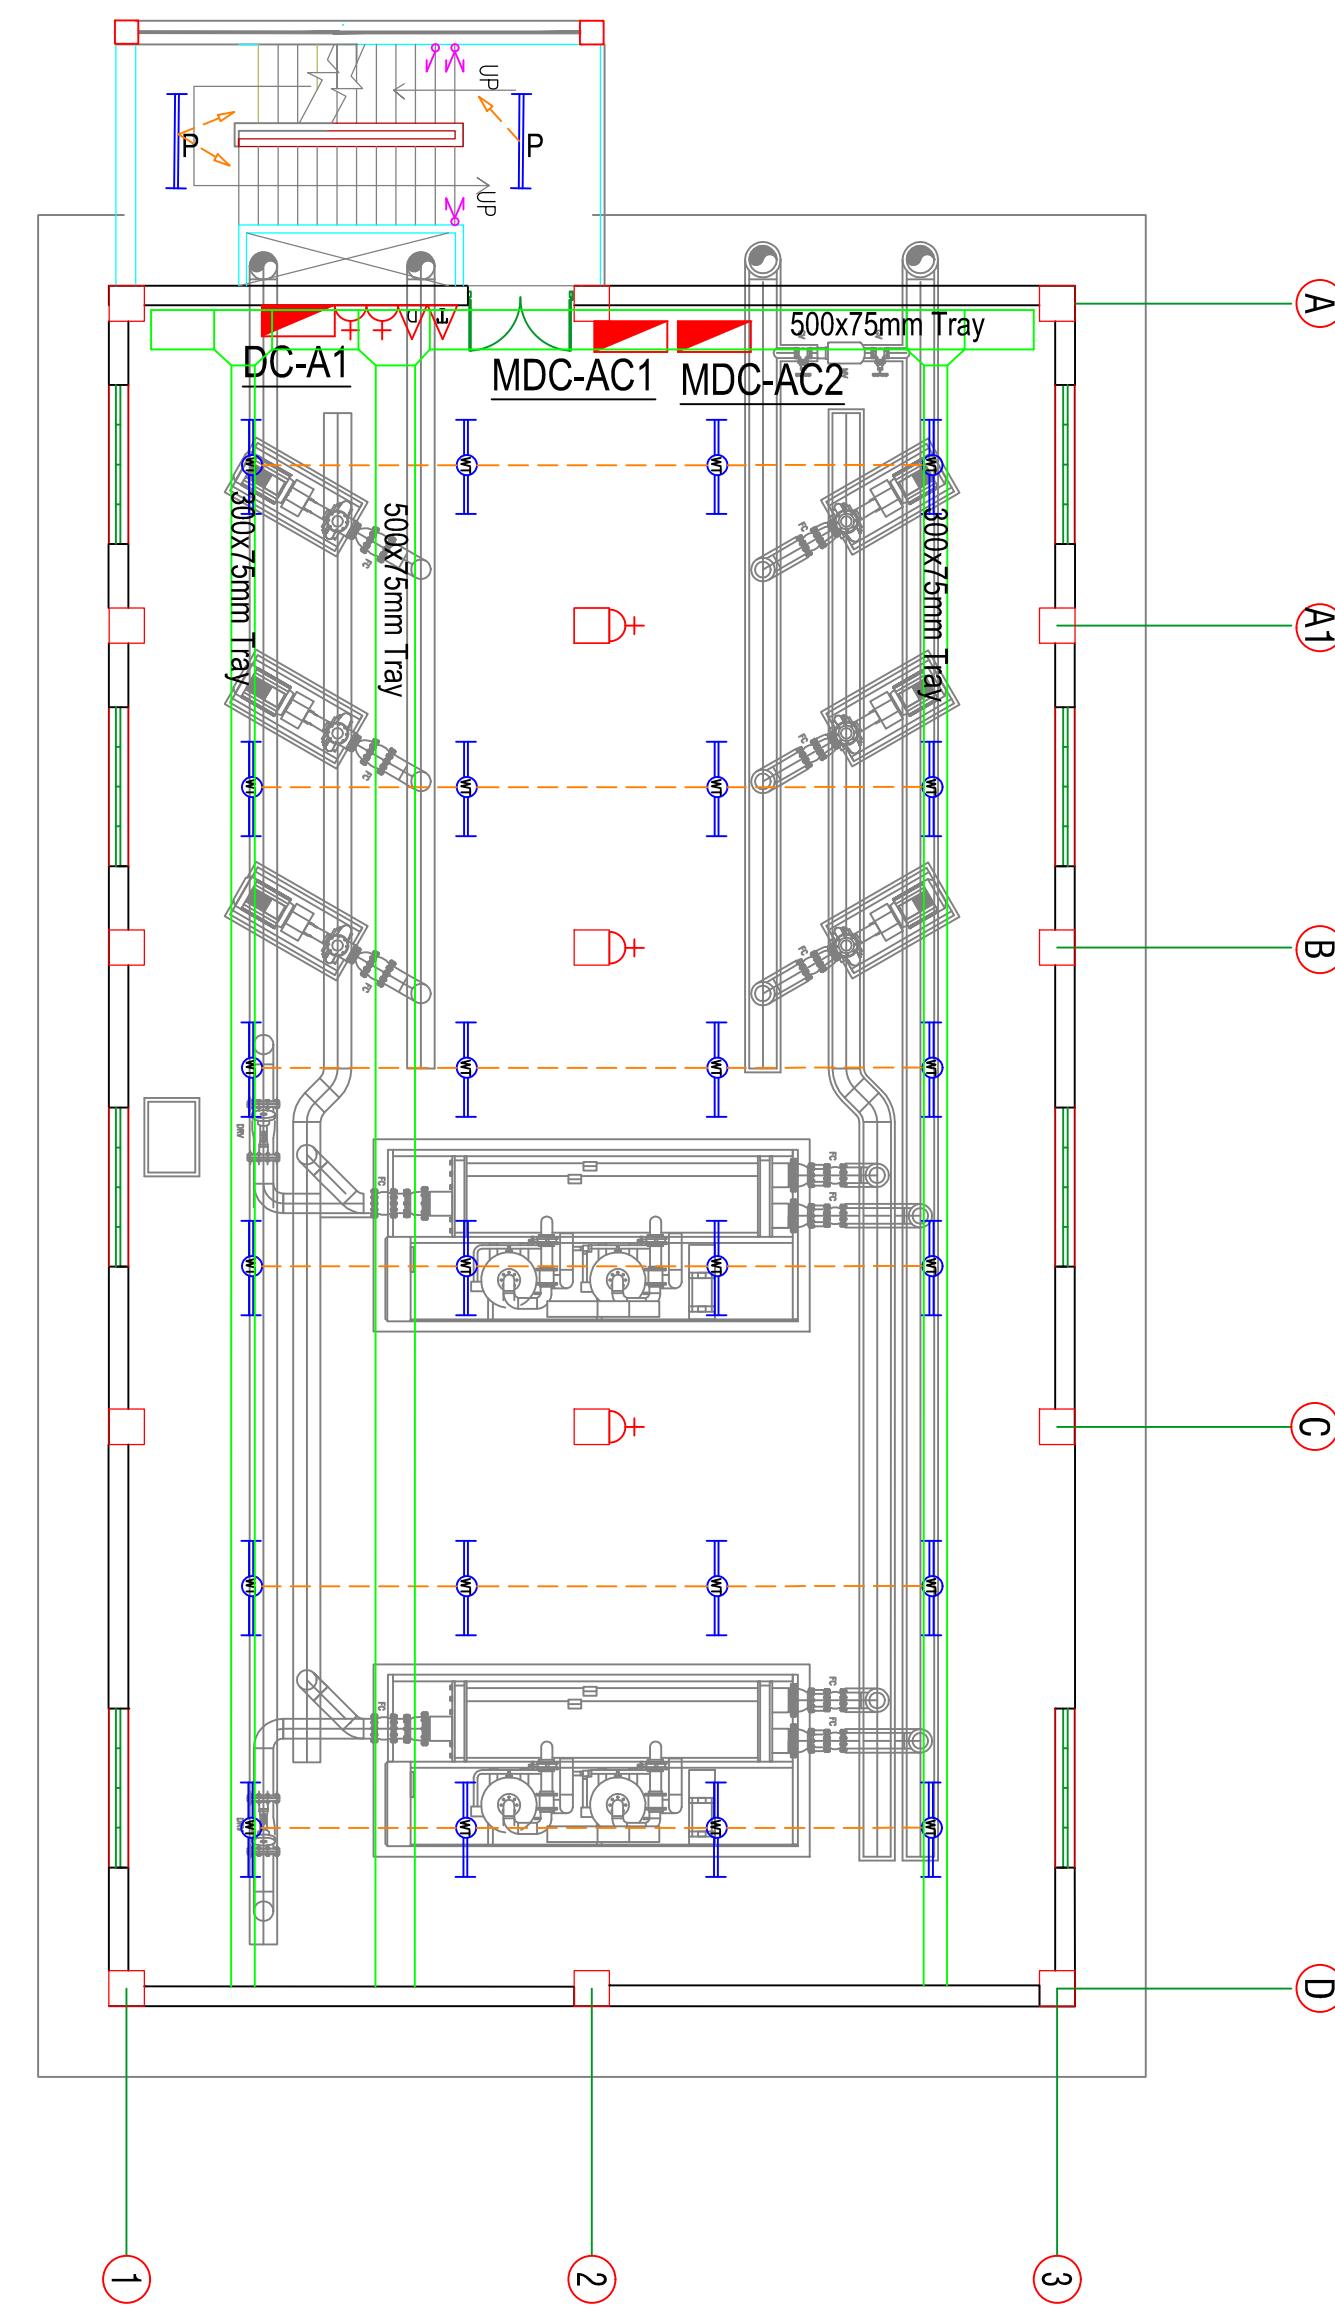
 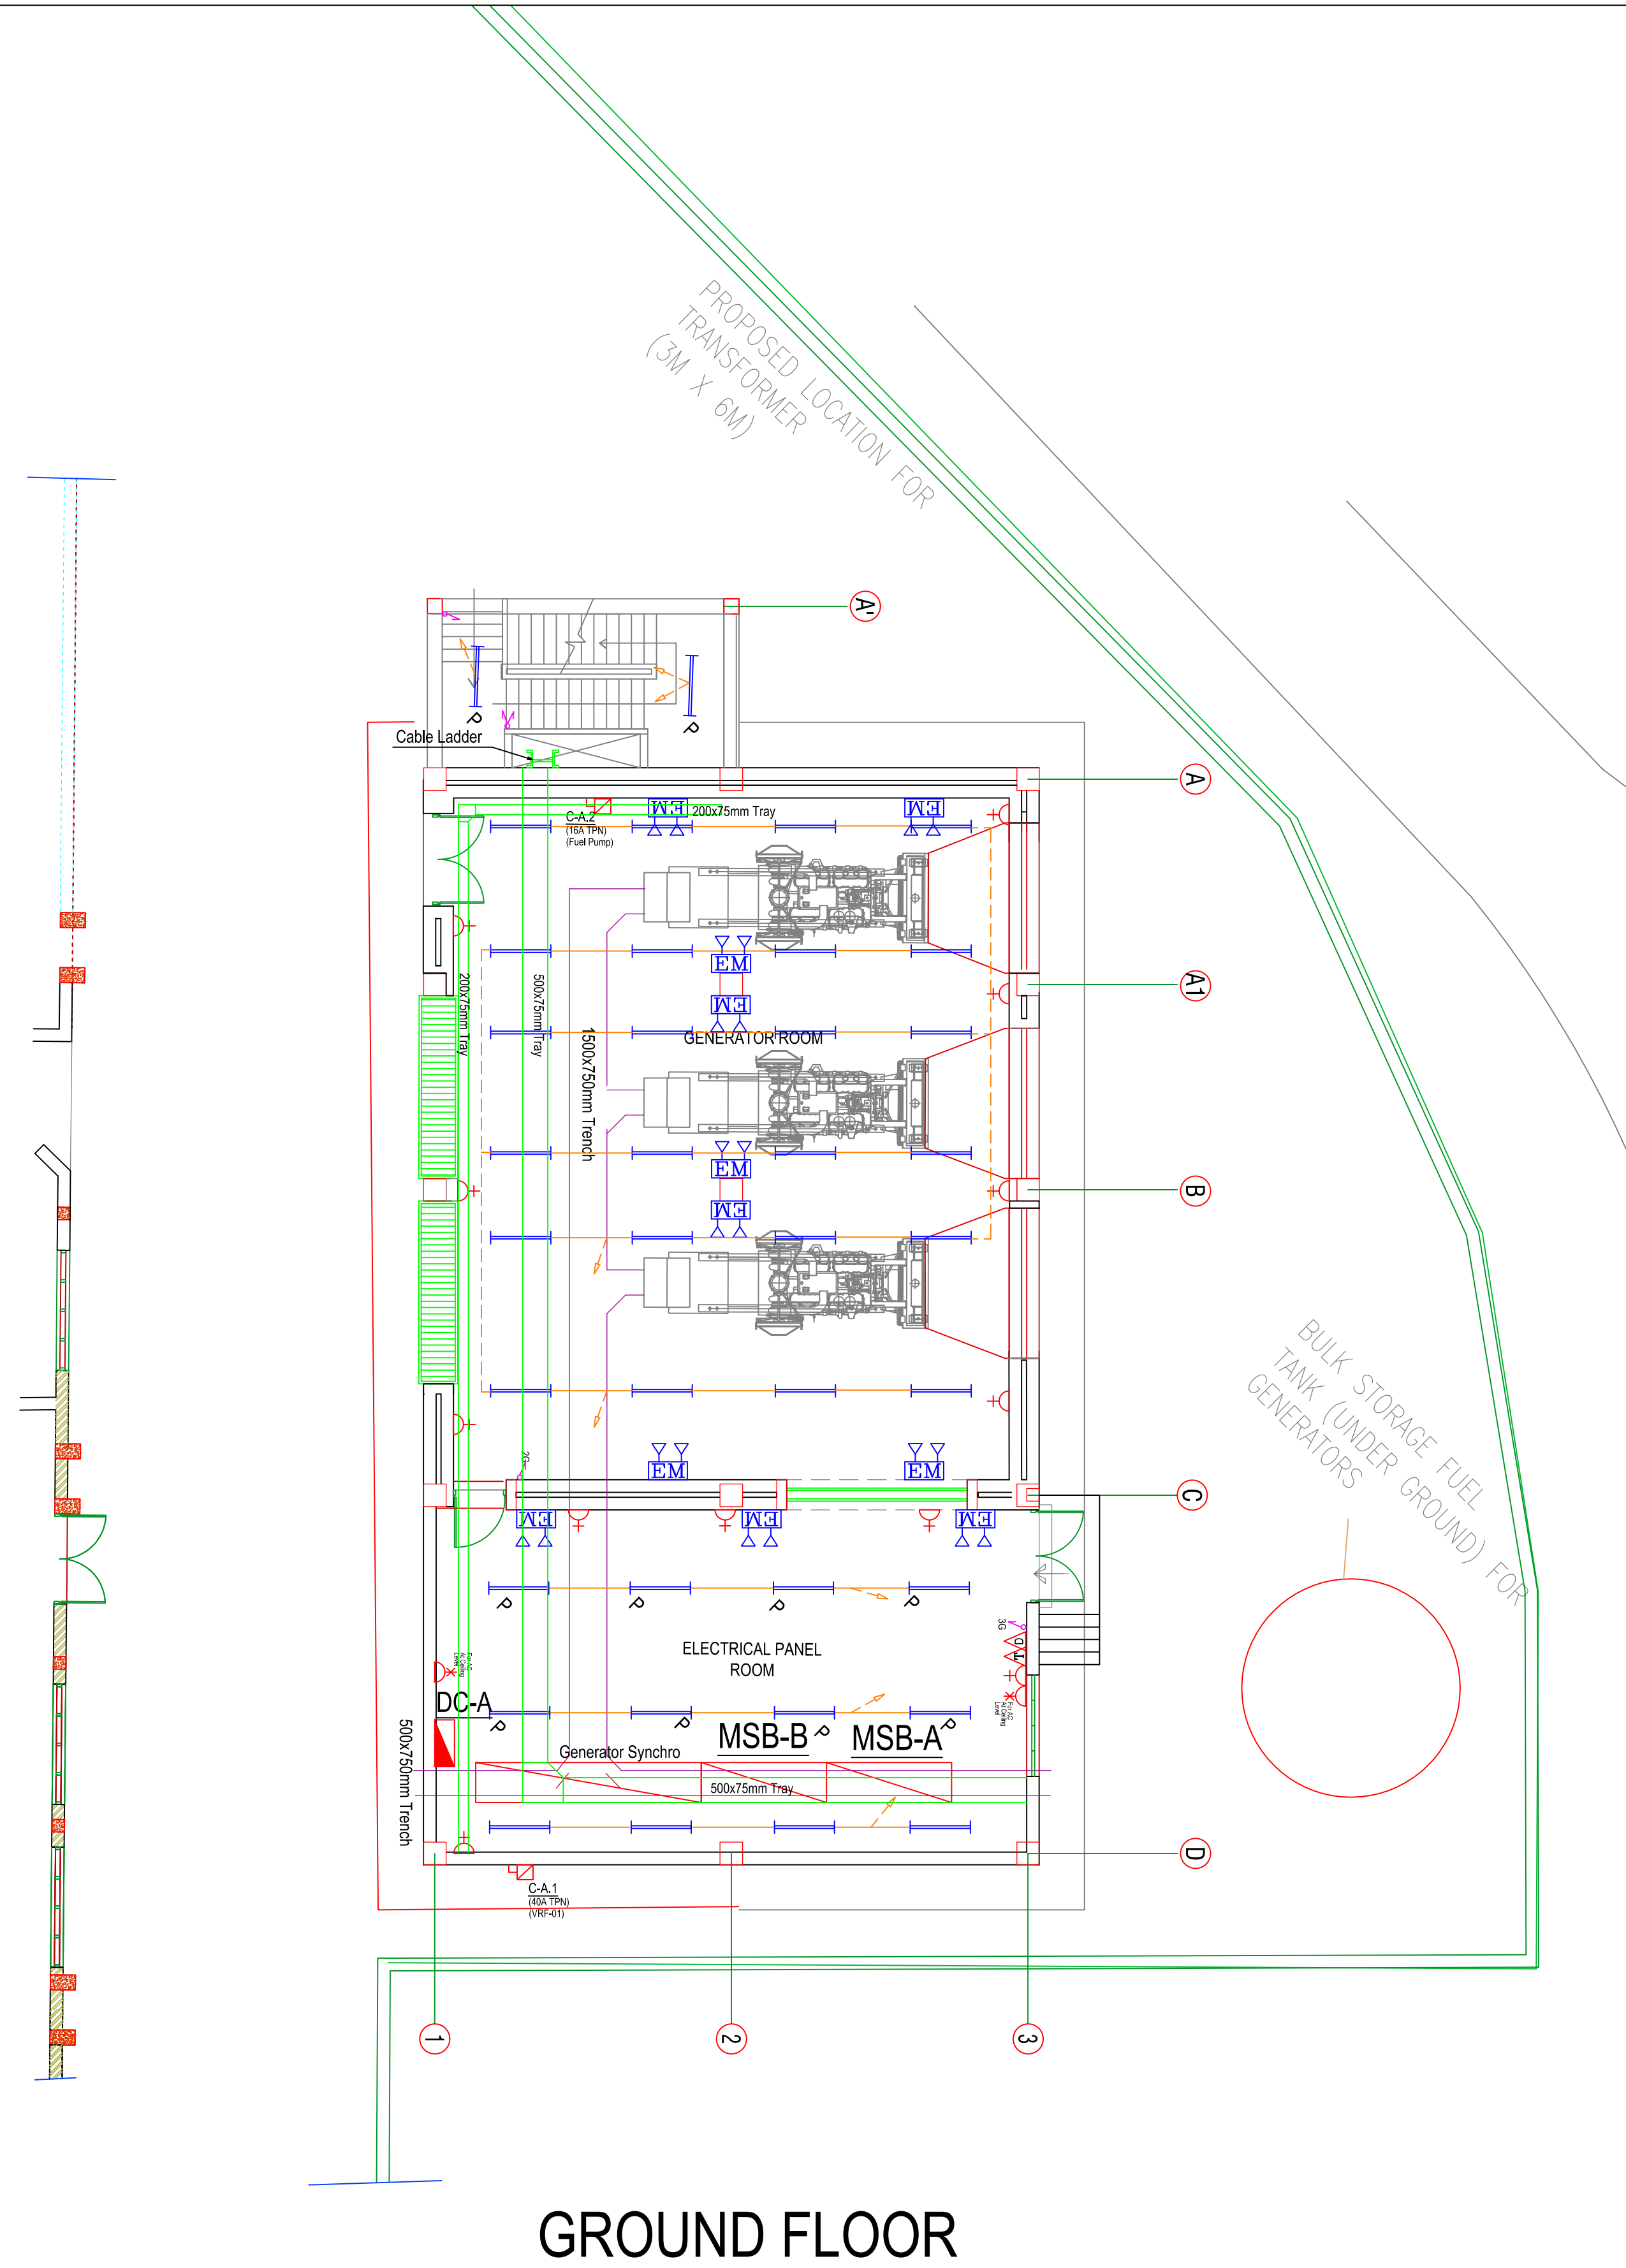




Project Title	Project Consultant					VERIFY ALL DIMENSIONS ON SITE BEFORE COMMENCING WORK COPYING OR THE REPRODUCTION OF THIS DRAWING IS STRICTLY PROHIBITED WITHOUT THE CONSENT OF NJ CONSULTANTS		
PROPOSED FACTORY FOR SOORTY TEXTILES (BD) LTD. PLOT NO 220-227, COMILLA EXPORT PROCESSING ZONE COMILLA - 3500, BANGLADESH	 NJ CONSULTANTS 35A, 1/3 , SUNETHRADEVI ROAD, KOHUWALA SRI LANKA TEL : 94-11-2814069, 94-11-4002365 FAX : 94-11-4002365 E-MAIL : noel@njpk.com					Drawing Title ELECTRICAL INSTALLATION SERVICE BUILDING - 02 LIGHTING, POWER LAYOUT	Drawn CADTEAM Date OCT 2013	
							Checked NJ Scale 1 : 75 @ A1	
							Approved Job No.	
							File Path	
							Dwg No. Revision	
							Drawing Status TENDER	E-SER-102 R0
Rev.	Description	Date	Made By					