


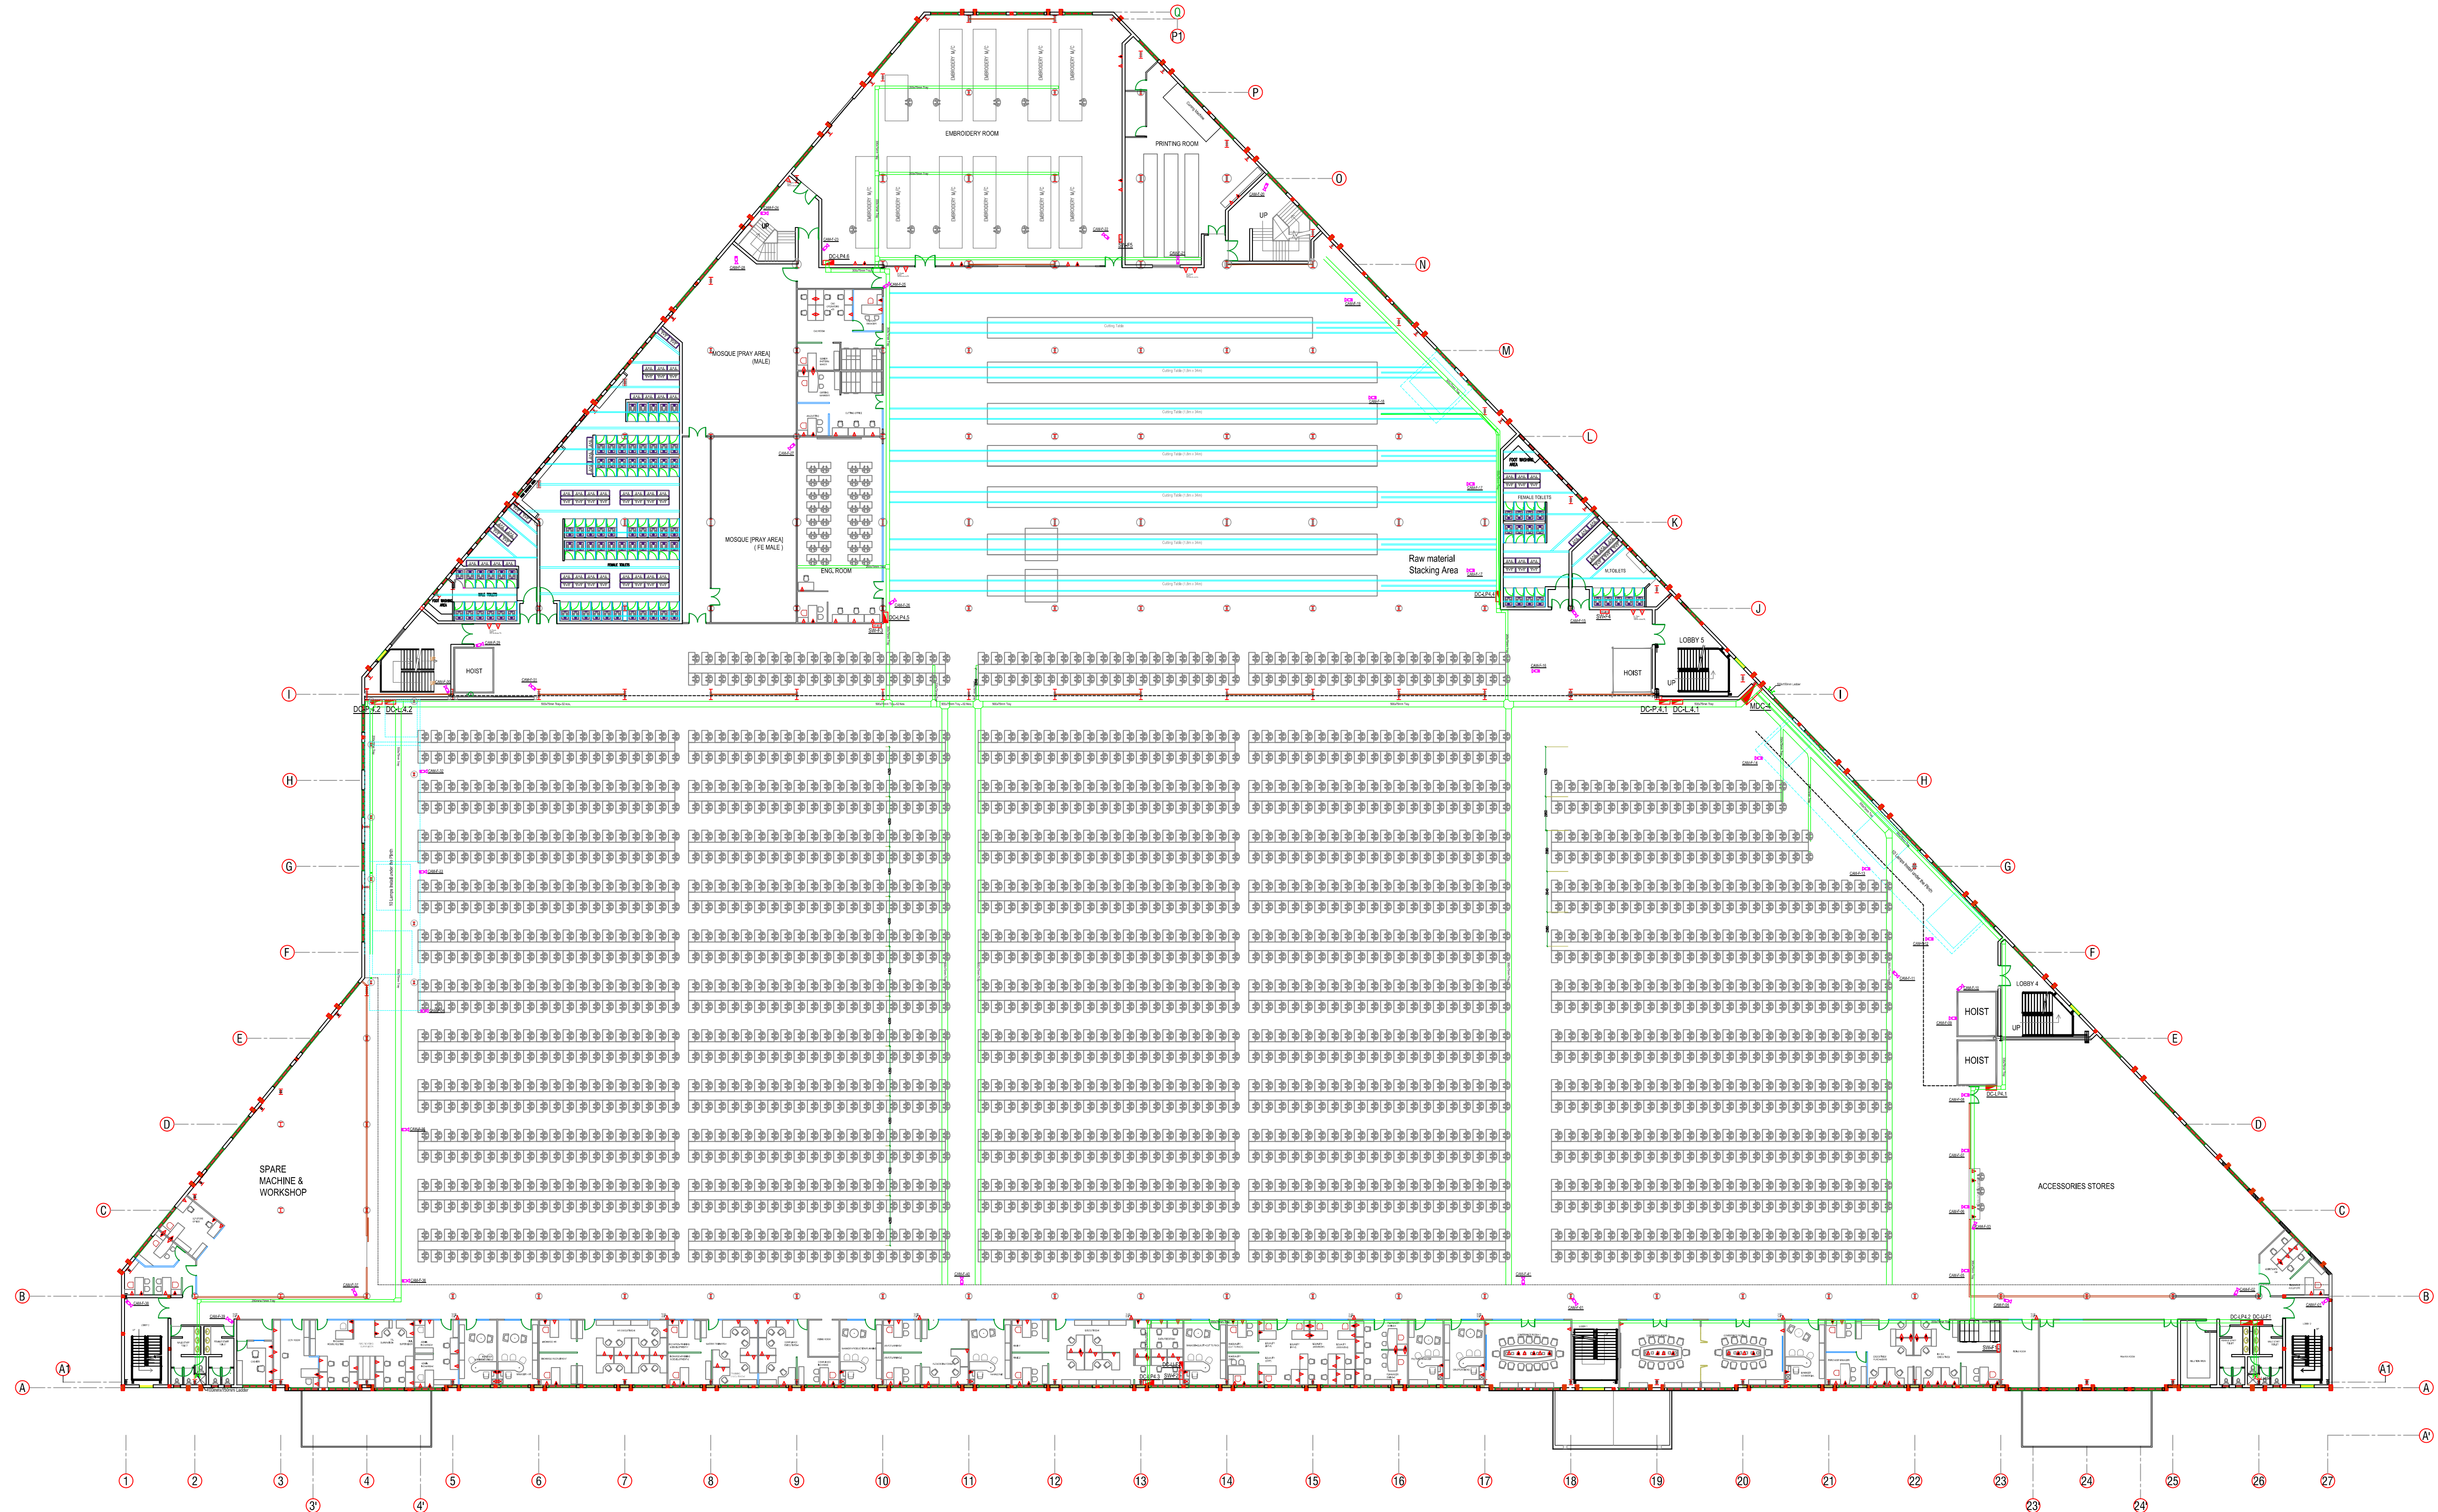

FIRST FLOOR PLAN

S

Project Title

PROPOSED FACTORY FOR
SOORTY TEXTILES (BD) LTD.
PLOT NO 220-227,
COMILLA EXPORT PROCESSING ZONE
COMILLA - 3500, BANGLADESH

Project Consultant



NJ CONSULTANTS

35A, 1/3, SUNETHRADEVI ROAD,
KOHUWALA
SRI LANKA

TEL: 94-11-2814069, 94-11-4002365
FAX: 94-11-4002365
E-MAIL: noel@njlk.com

R3	Lighting Layout Revised	March 14	NJC
R2	Machine Layout Revised	March 14	NJC
R1	Machine Layout Revised	Jan 14	Client

Rev.

Description

March 14	NJC
Jan 14	Client

Date

Made By

VERIFY ALL DIMENSIONS ON SITE BEFORE COMMENCING WORK.
COPYING OR THE REPRODUCTION OF THIS DRAWING IS STRICTLY
PROHIBITED WITHOUT THE CONSENT OF NJ CONSULTANTS

Drawing Title

ELV INSTALLATION
FIRST FLOOR PLAN
CCTV LAYOUT

Drawing Status

CONSTRUCTION

Drawn	CADTEAM	Date	AUG 2013
Checked	NJ	Scale	1 : 300 © A1
Approved		Job No.	
File Path			
Dwg No.		Revision	
	CCTV-F-MP-100	R3	