


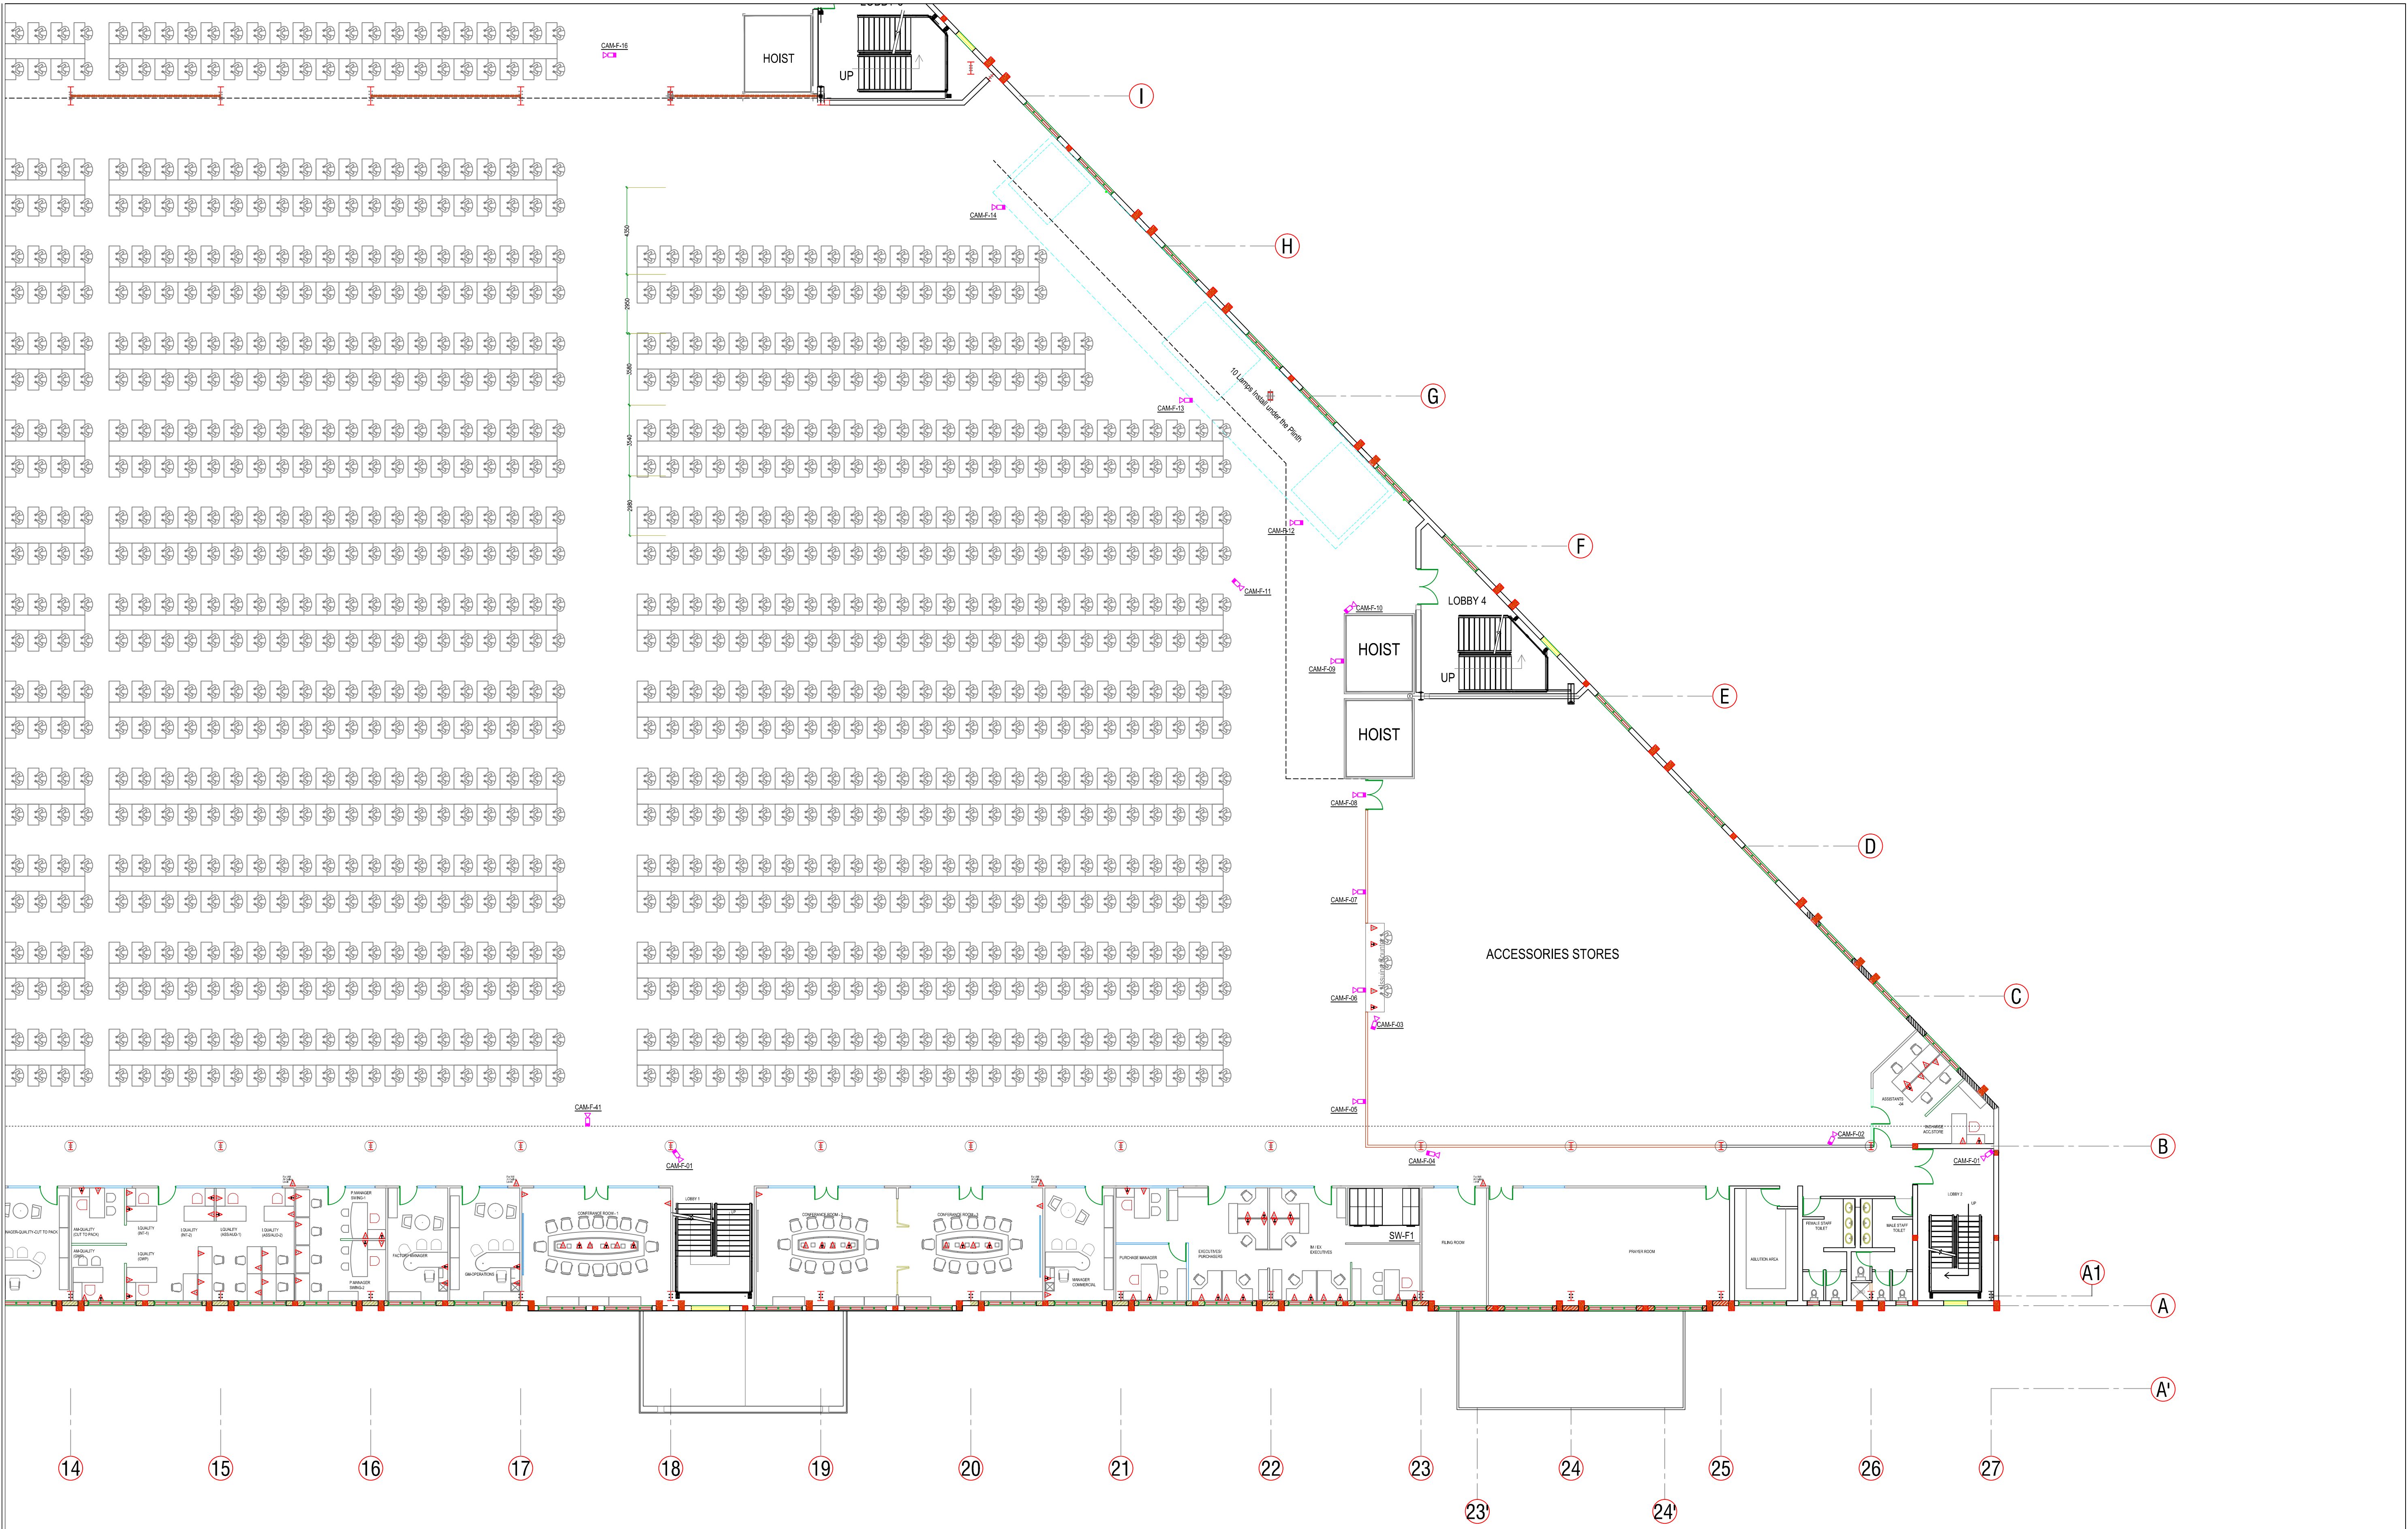

Project Title		Project Consultant				VERIFY ALL DIMENSIONS ON SITE BEFORE COMMENCING WORK COPYING OR THE REPRODUCTION OF THIS DRAWING IS STRICTLY PROHIBITED WITHOUT THE CONSENT OF NJ CONSULTANTS	
PROPOSED FACTORY FOR SOORTY TEXTILES (BD) LTD. PLOT NO 220-227, COMILLA EXPORT PROCESSING ZONE COMILLA - 3500, BANGLADESH		 NJ CONSULTANTS 35A, 1/3, SUNETHRADEVI ROAD, KOHUWALA SRI LANKA TEL : 94-11-2814069, 94-11-4002365 FAX : 94-11-4002365 E-MAIL : noel@njc.com				Drawing Title ELV INSTALLATION FIRST FLOOR - GRID 15 - 27 & A - I CCTV LAYOUT	
				R1		Drawing Status	
				Machine Layout Revised		CONSTRUCTION	
				Rev.		Description	
				Jan 14		Client	
				Date		Made By	
						Dwg No.	
						Revision	
						CCTV-F-102	
						R1	