


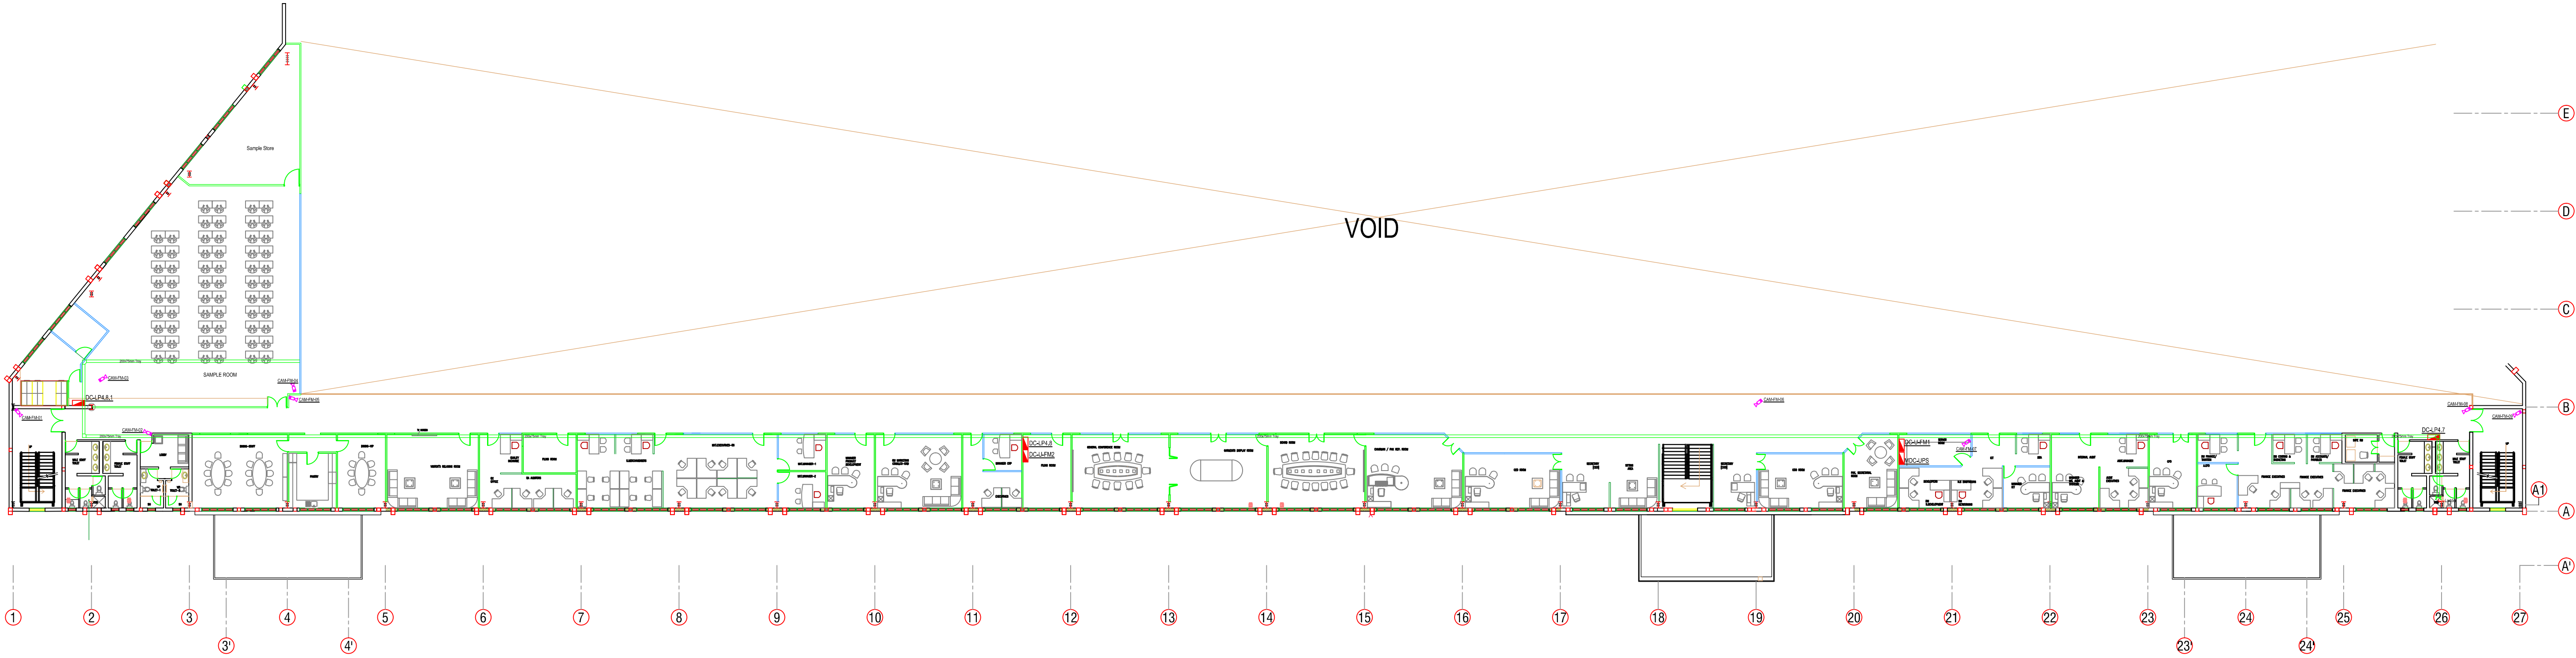

MEZZANINE FLOOR PLAN

Project Title PROPOSED FACTORY FOR SOORTY TEXTILES (BD) LTD. PLOT NO 220-227, COMILLA EXPORT PROCESSING ZONE COMILLA - 3500, BANGLADESH	Project Consultant  NJ CONSULTANTS 35A, 1/3, SUNETHRADEVI ROAD, KOHUWALA, SRI LANKA TEL : 94-11-2814069, 94-11-4002365 FAX : 94-11-4002365 E-MAIL : noel@njc.lk	Rev.	Description	Date	Made By	VERIFY ALL DIMENSIONS ON SITE BEFORE COMMENCING WORK COPYING OR THE REPRODUCTION OF THIS DRAWING IS STRICTLY PROHIBITED WITHOUT THE CONSENT OF NJ CONSULTANTS		
						Drawing Title ELV INSTALLATION MEZZANINE FLOOR IN FIRST LEVEL CCTV LAYOUT	Drawn CADTEAM	Date AUG 2013
							Checked NJ	Scale 1 : 250 © A1
							Approved	Job No.
						Drawing Status CONSTRUCTION	Dwg No. CCTV-FM-MP-100	Revision R1