


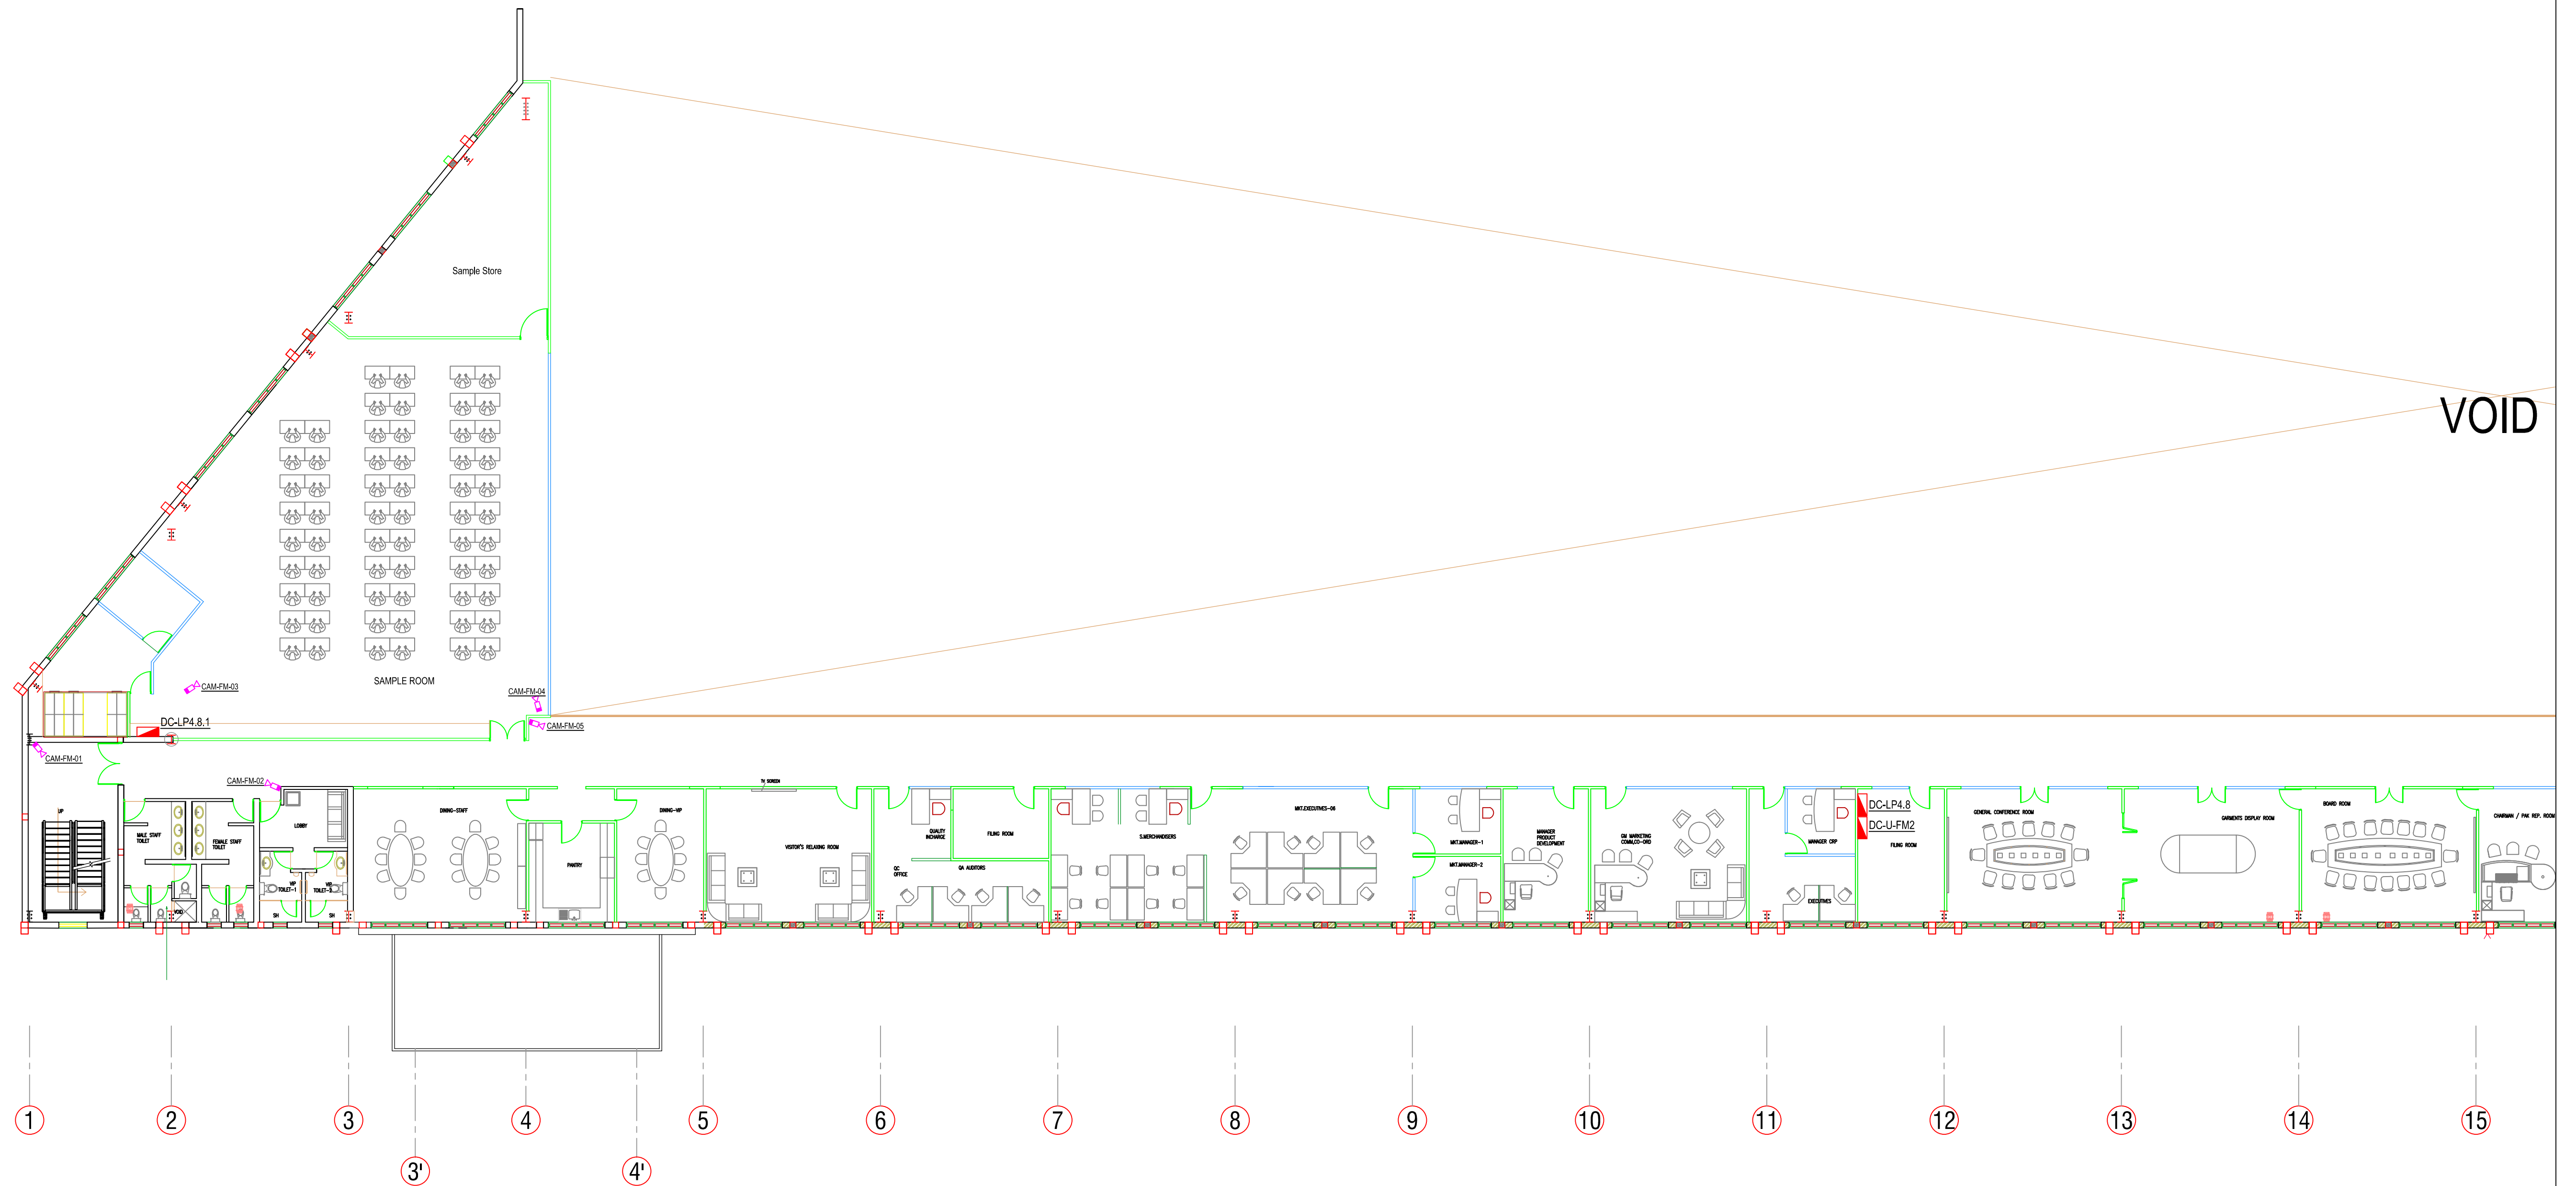

MEZZANINE FLOOR PLAN

Project Title		Project Consultant				VERIFY ALL DIMENSIONS ON SITE BEFORE COMMENCING WORK COPYING OR THE REPRODUCTION OF THIS DRAWING IS STRICTLY PROHIBITED WITHOUT THE CONSENT OF NJ CONSULTANTS	
PROPOSED FACTORY FOR SOORTY TEXTILES (BD) LTD. PLOT NO 220-227, COMILLA EXPORT PROCESSING ZONE COMILLA - 3500, BANGLADESH		 NJ CONSULTANTS 35A, 1/3, SUNETHRADEVI ROAD, KOHUWALA, SRI LANKA TEL : 94-11-2814069, 94-11-4002365 FAX : 94-11-4002365 E-MAIL : noel@njc.lk.com				Drawing Title	Drawn CADTEAM Date OCT 2013
						ELV INSTALLATION MEZZANINE FLOOR IN FIRST LEVEL CCTV LAYOUT	Checked NJ Scale 1 : 150 © A1
							Approved Job No.
							Dwg No. Revision
				Rev.	Description	Date	Made By
						Drawing Status	CONSTRUCTION
							CCTV-FM-101 R0